

NOTES THIS SHEET

- 1 DN 6 RISERS AT 7.0", 5 TREADS AT 14" WITH 1" NOSING
- 2 UP 21 RISERS AT 7.62", 20 TREADS AT 10" WITH 1" NOSING
- 3 DN 5 RISERS AT 6.4", 4 TREADS AT 14" WITH 1" NOSING
- 4 DN 7 RISERS AT 7.0", 6 TREADS AT 11" WITH 1" NOSING
- 5 DN 3 RISERS AT 7.0", 2 TREADS AT 11" WITH 1" NOSING
- 6 1 HR RATED PARTITION. 5/8" TYPE "X" GWB EACH SIDE
- 7 42" GAS FIREPLACE
- 8 WELL PUMP
- 9 WATER SOFTENER SYSTEM
- 10 WATER HEATER
- 11 BENCH WITH COAT HOOKS

ELECTRICAL LEGEND

- STRUCTURED WIRING TELEPHONE / CABLE EACH LOCATION SWITCH
- THREE WAY SWITCH
- DIMMER SWITCH
- DUPLEX RECEPTACLE
- GROUND FAULT INTERRUPT RECEPTACLE
- WEATHER PROOF RECEPTACLE
- SPECIAL POWER OUTLET
- CEILING MOUNT SPEAKER
- DUPLEX RECEPTACLE

Window Schedule

Description	Quantity
Mark A	1
Mark B	1
Mark C	4
Mark D	2
Mark D Temp	2
Mark E	4
Mark F	1
Mark G	2
Mark H	2
Mark J	1
Mark K Temp	1
Mark K Temp	1
Mark K Temp	2
Mark K Temp	2

SQUARE FOOTAGE

FIRST FLOOR HEATED	4982 SF
SECOND FLOOR HEATED	800 SF
REAR PORCH	860 SF
GARAGE	1006 SF
TOTAL HEATED	6642 SF


 
PLAN LEGEND


 
- SMOKE DETECTOR, HARDWIRED AND INTERCONNECTED
- CARBON MONOXIDE DETECTOR
- EXHAUST FAN
- RECESSED FIRE EXTINGUISHER CABINET MOUNTED AT 60" AFF MAX PROVIDE 2-A:10-B:C FIRE EXTINGUISHER






FIRST FLOOR PLAN

1/4" = 1'-0"

GRAPHIC SCALES

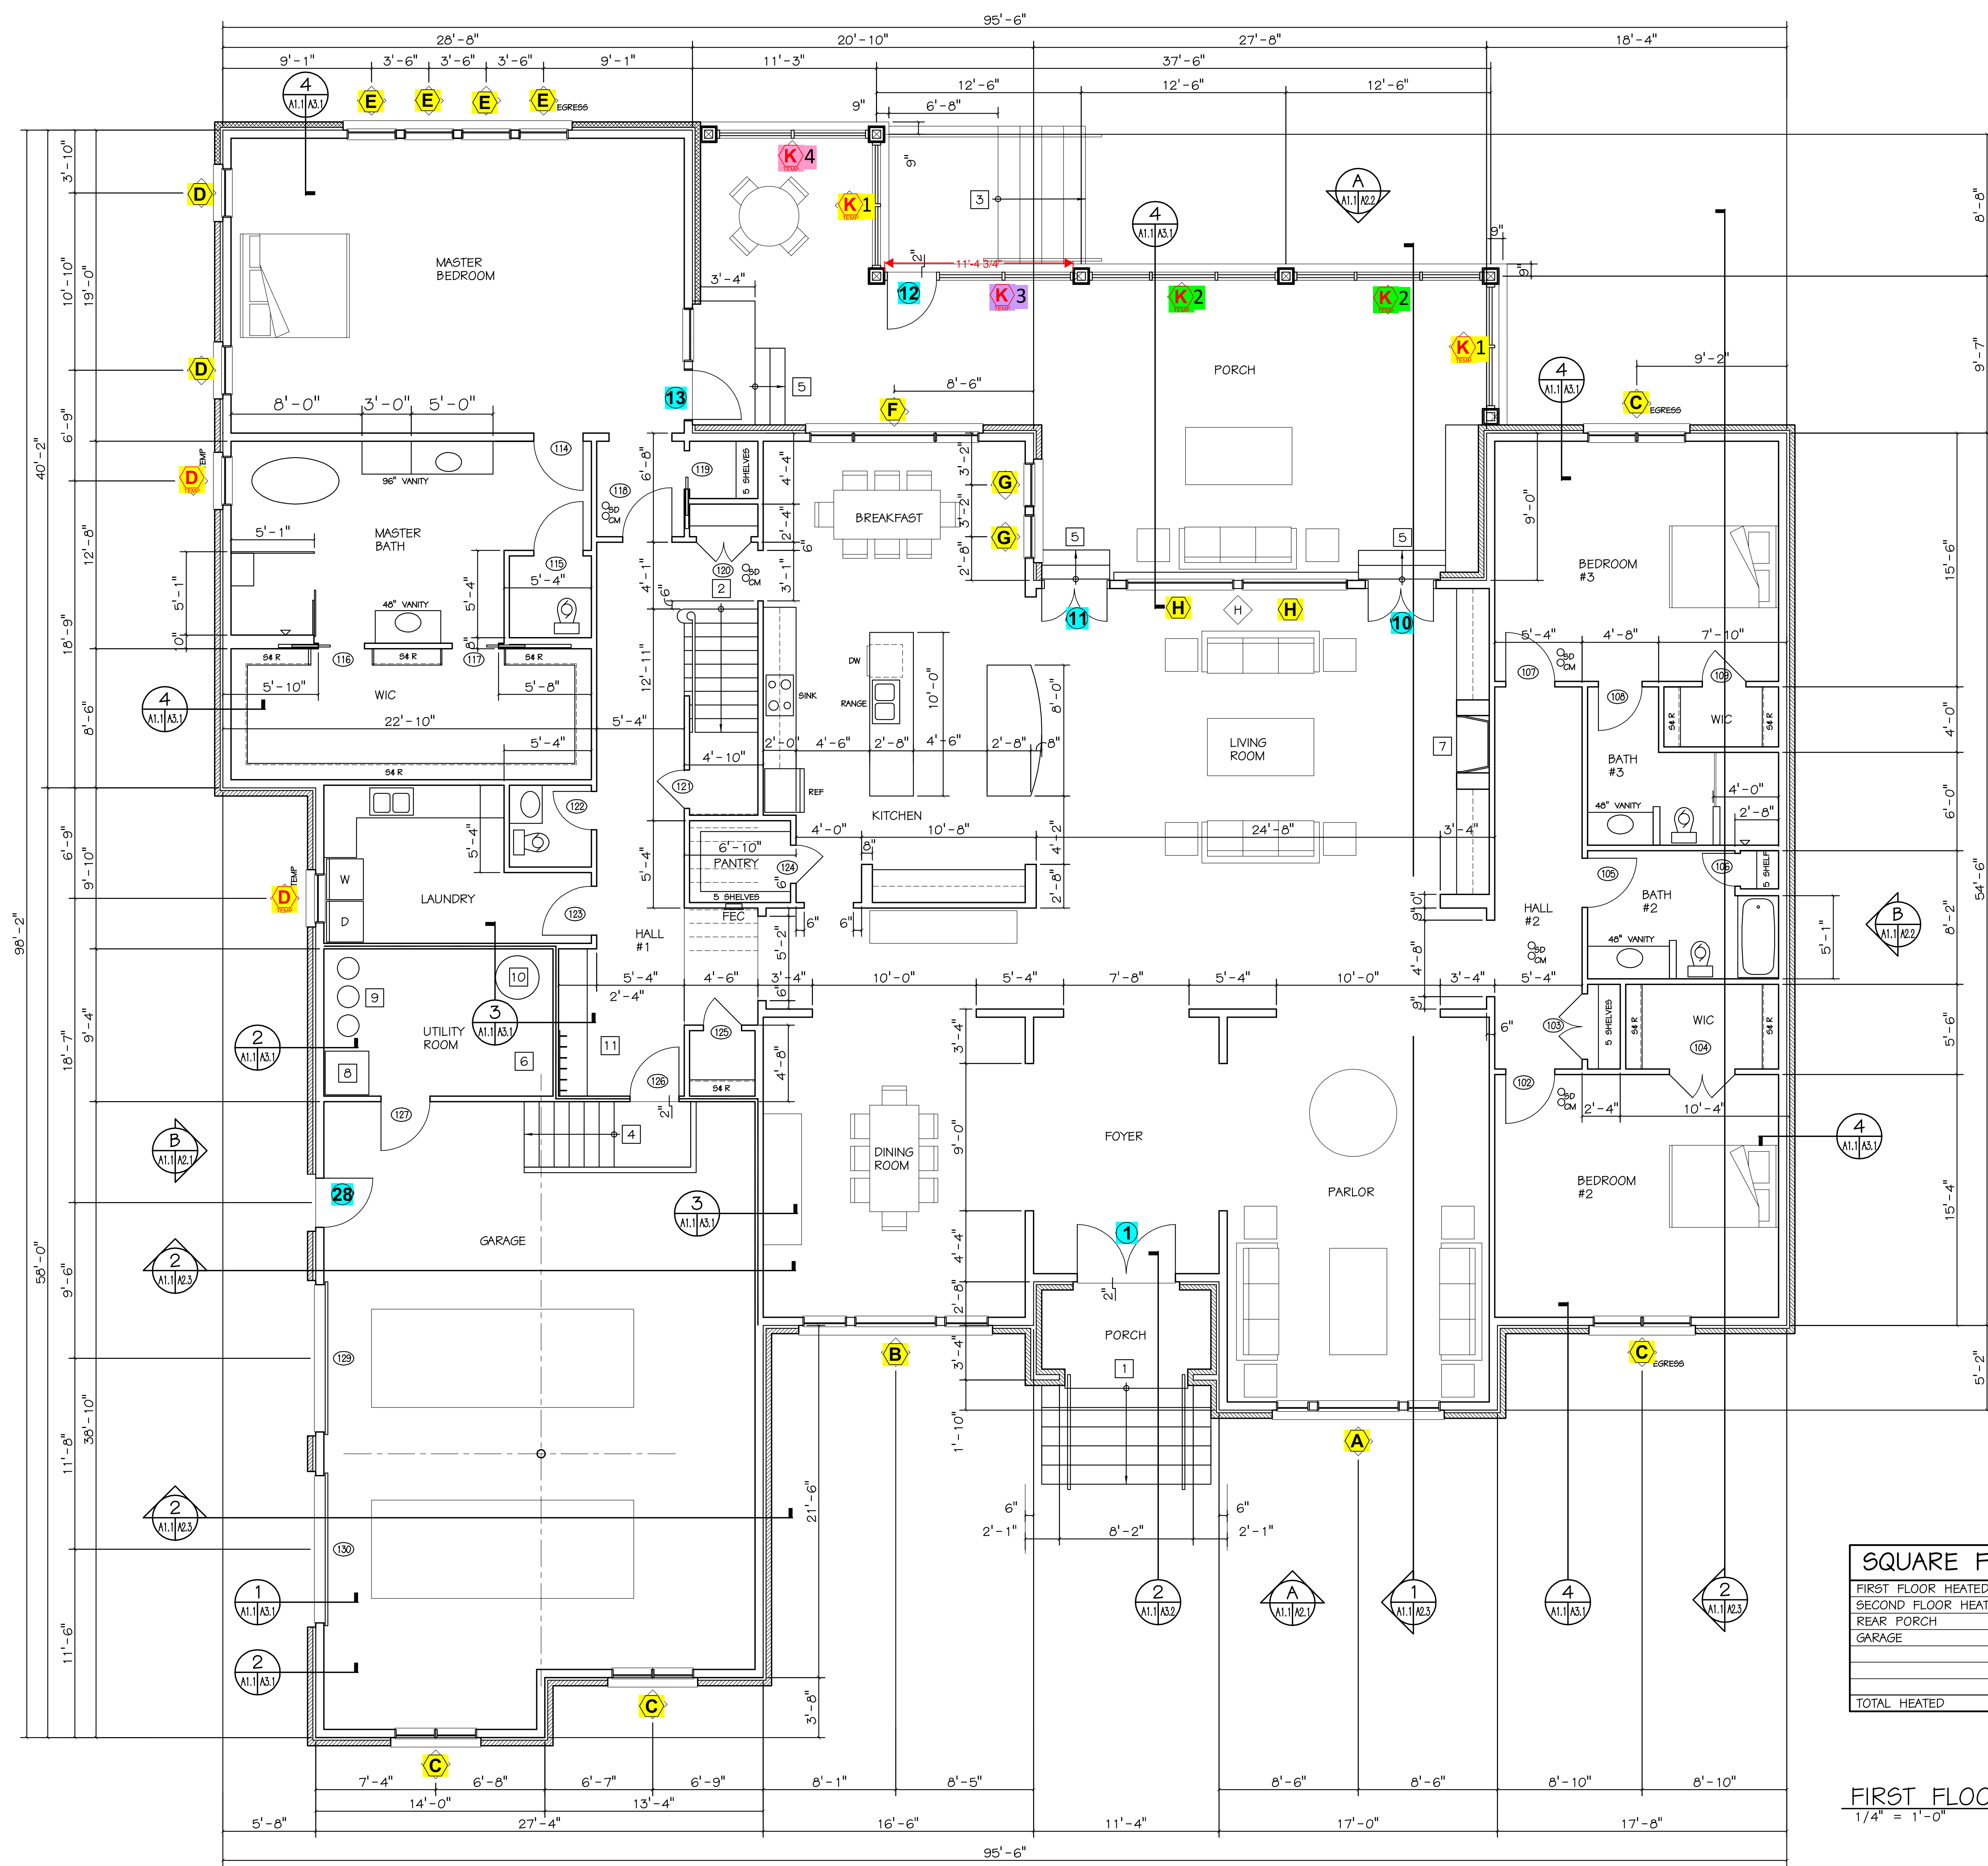

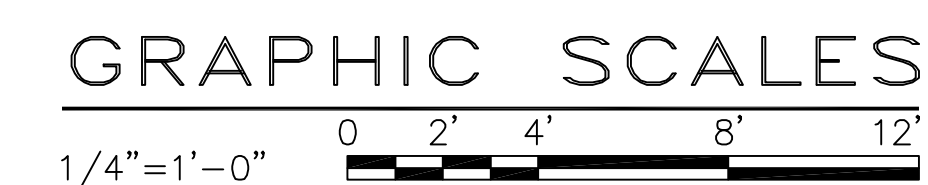

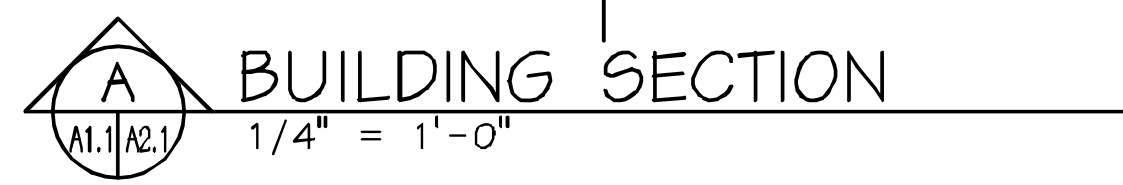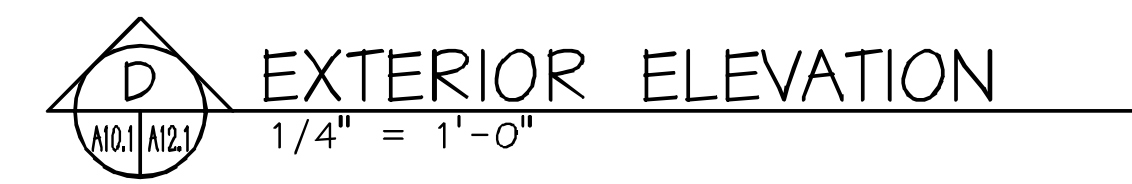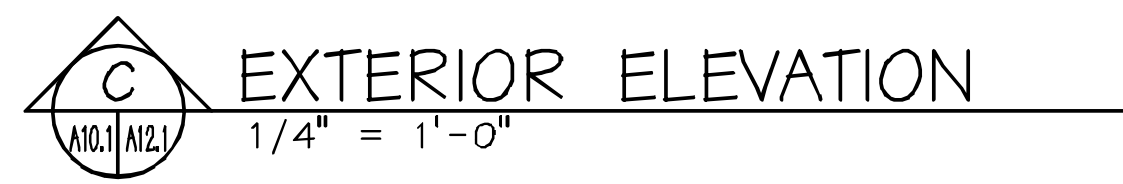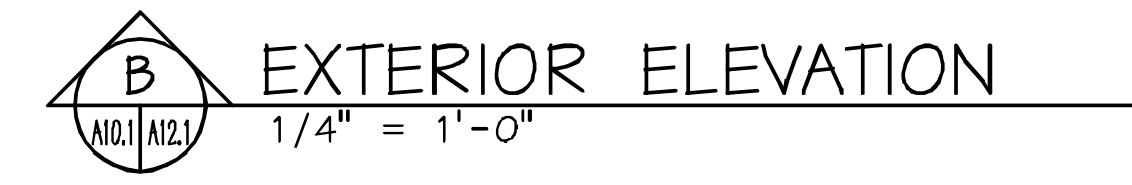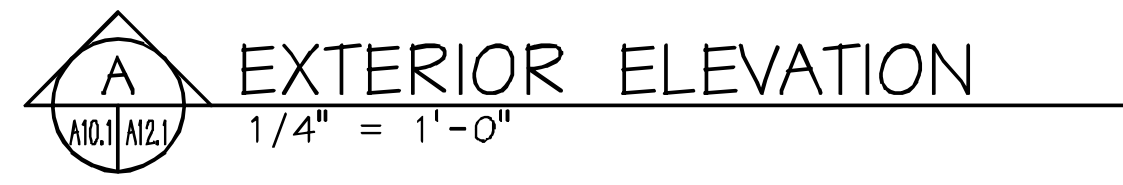

GRAPHIC SCALES

1/4"=1'-0"

A horizontal graphic scale bar with alternating black and white segments. Above the bar, the increments 0, 2', 4', 8', and 12' are marked. To the left of the bar, the scale is defined as 1/4"=1'-0".

	21081		SPL	DESIGNED
		DATE	SPL	DRAWN
			SPL	CHECKED
		26 AUG 2021		

TITLE CONVEYANCE

LOT B-1 / HEAD RIVER RD	VIRGINIA BEACH, VIRGINIA
SHEET TITLE	EXTERIOR ELEVATIONS / BUILDING SECTION

**HOLE
ARCHITECTS**
PRODUCTION
02
BEACH, VIRGINIA 23454
88-2620
HOLE@GMAIL.COM

SHEET NUMBER

A-12.1

XX OF XX