


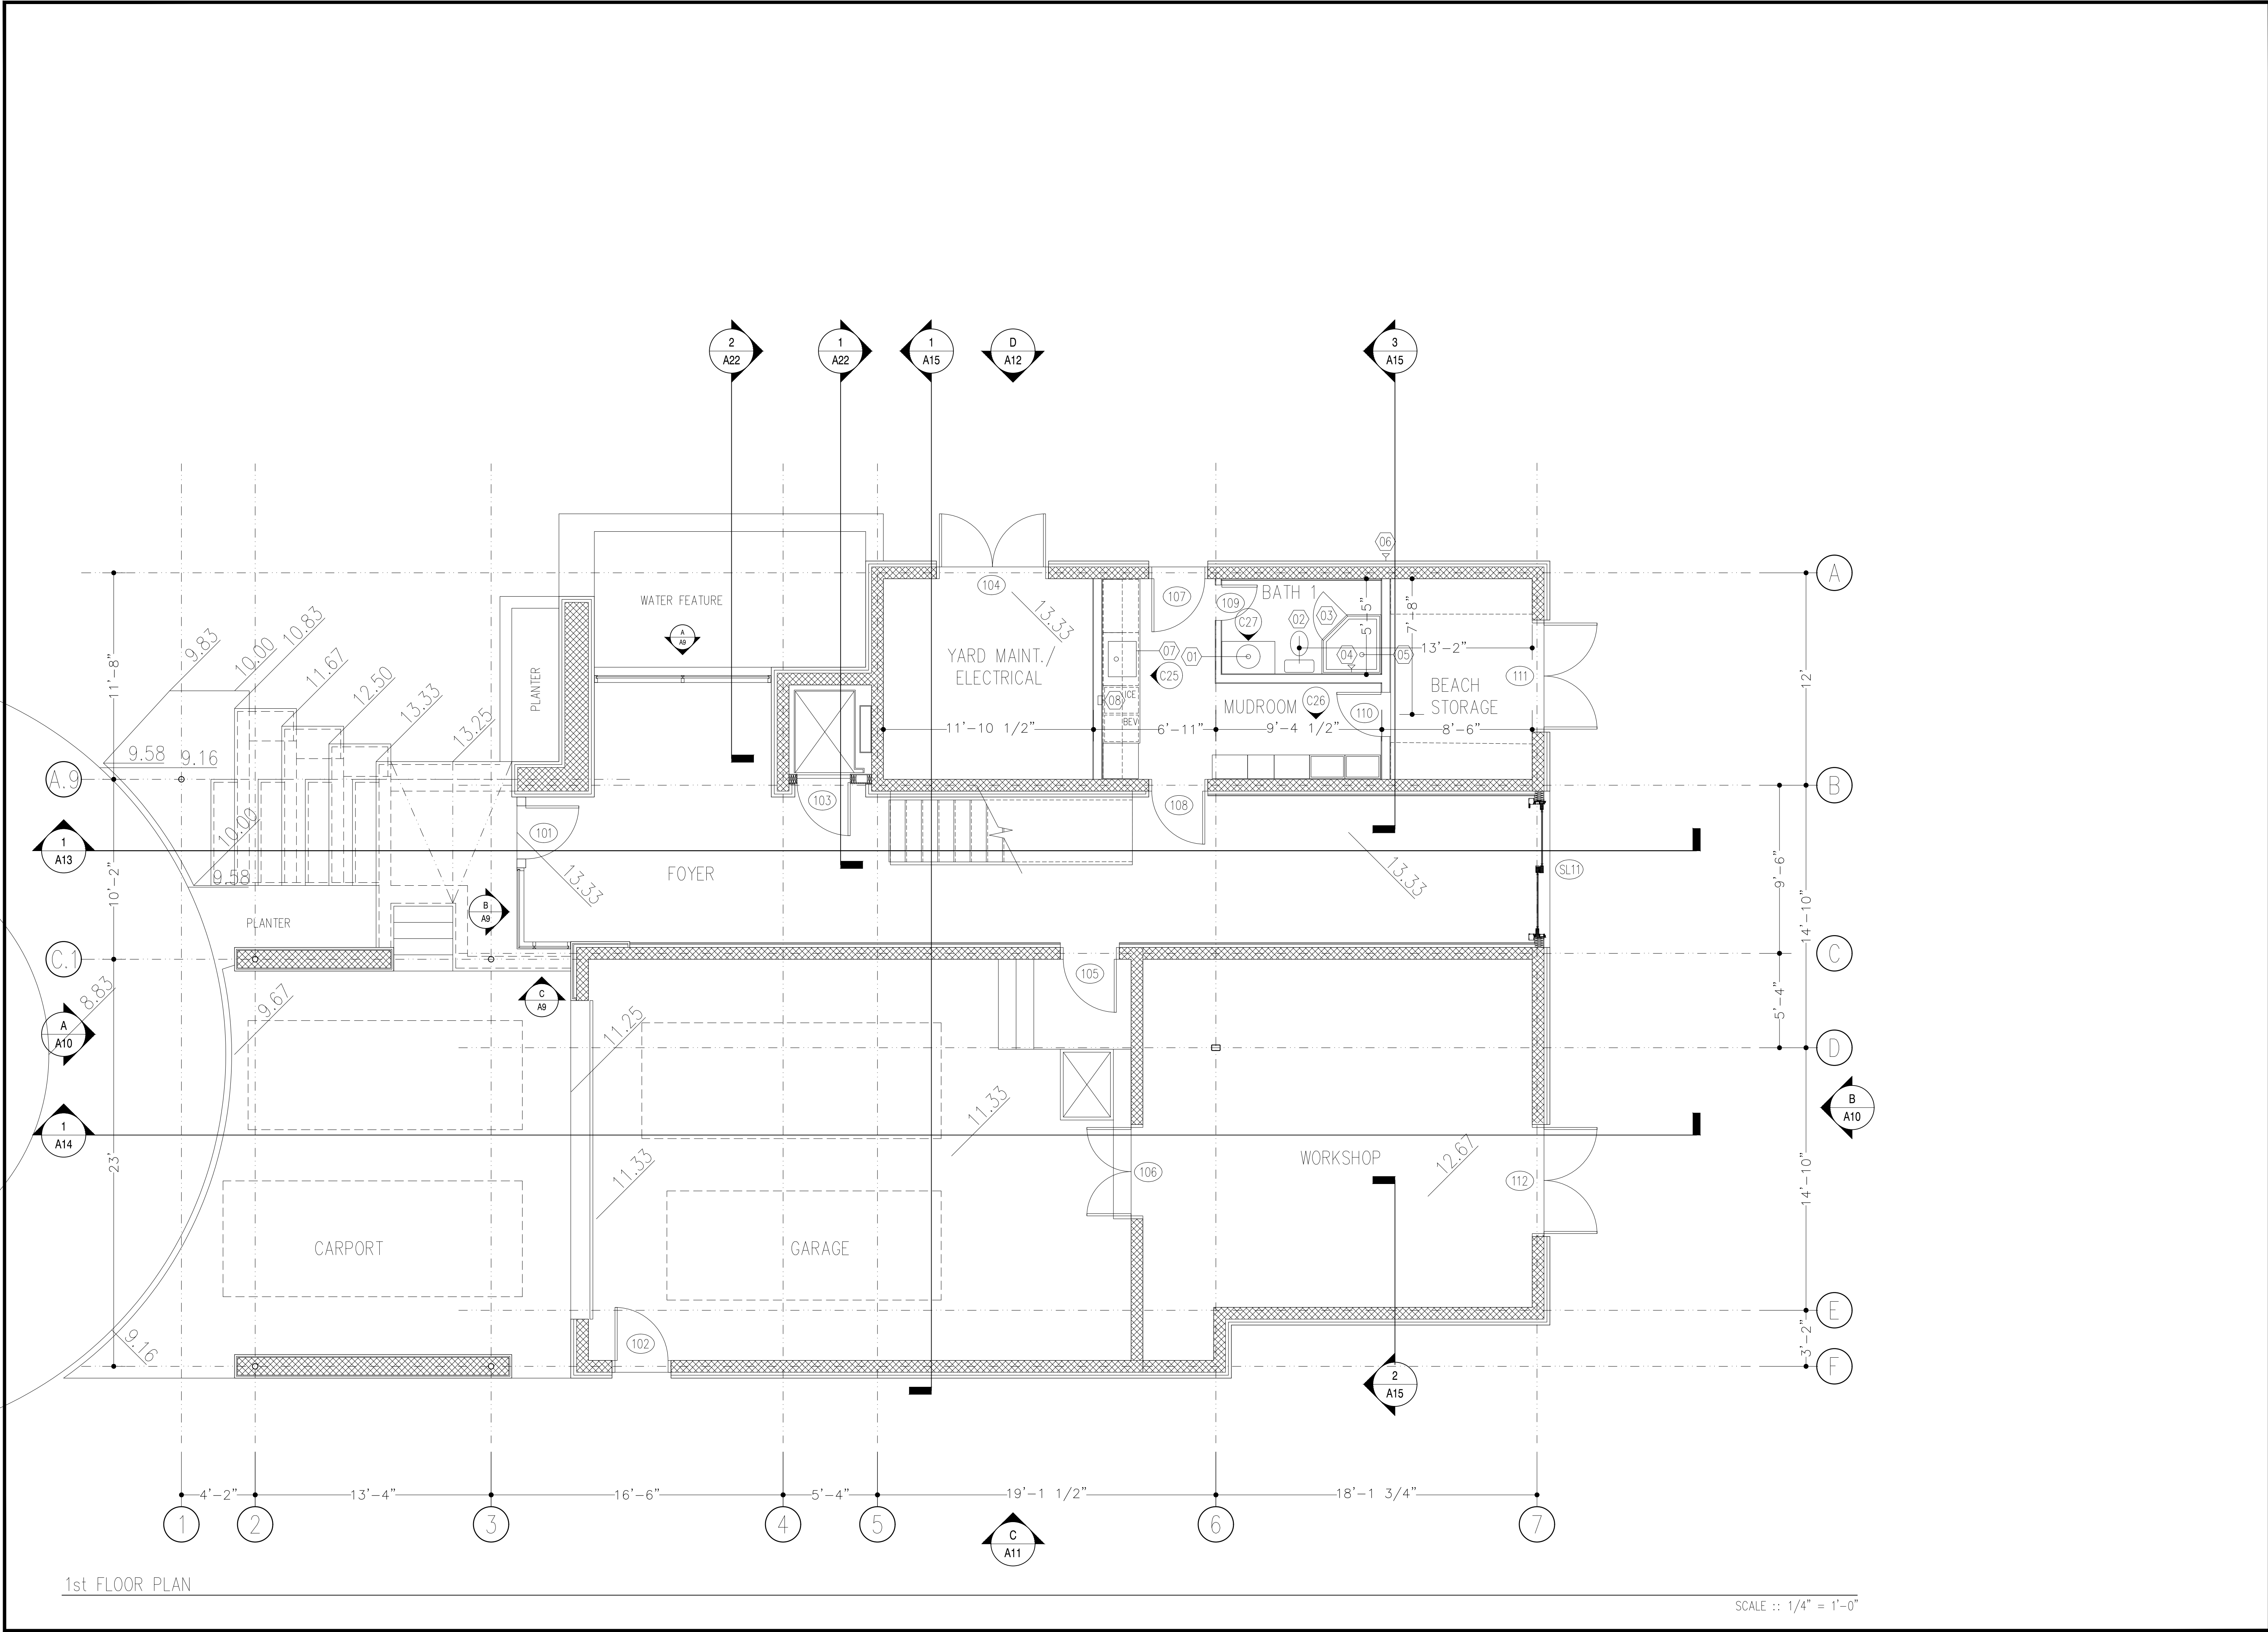

1st FLOOR PLAN

SCALE :: 1/4" = 1'-0"



DEBBIE & MICHAEL ROSS RESIDENCE
2726 E OCEAN VIEW AVE

ISSUED FOR: MARK: DATE: 03-27-22
75% DESIGN

StudioRoss LLC
223 82nd Street
Virginia Beach, VA 23451
757-323-2209

1st FLOOR PLAN

A1

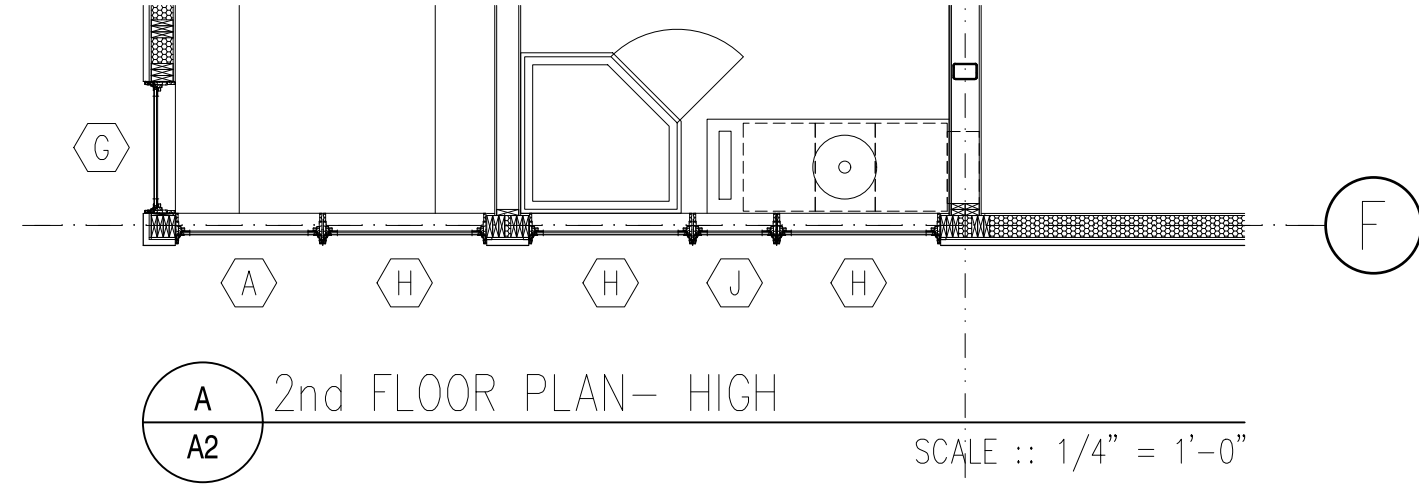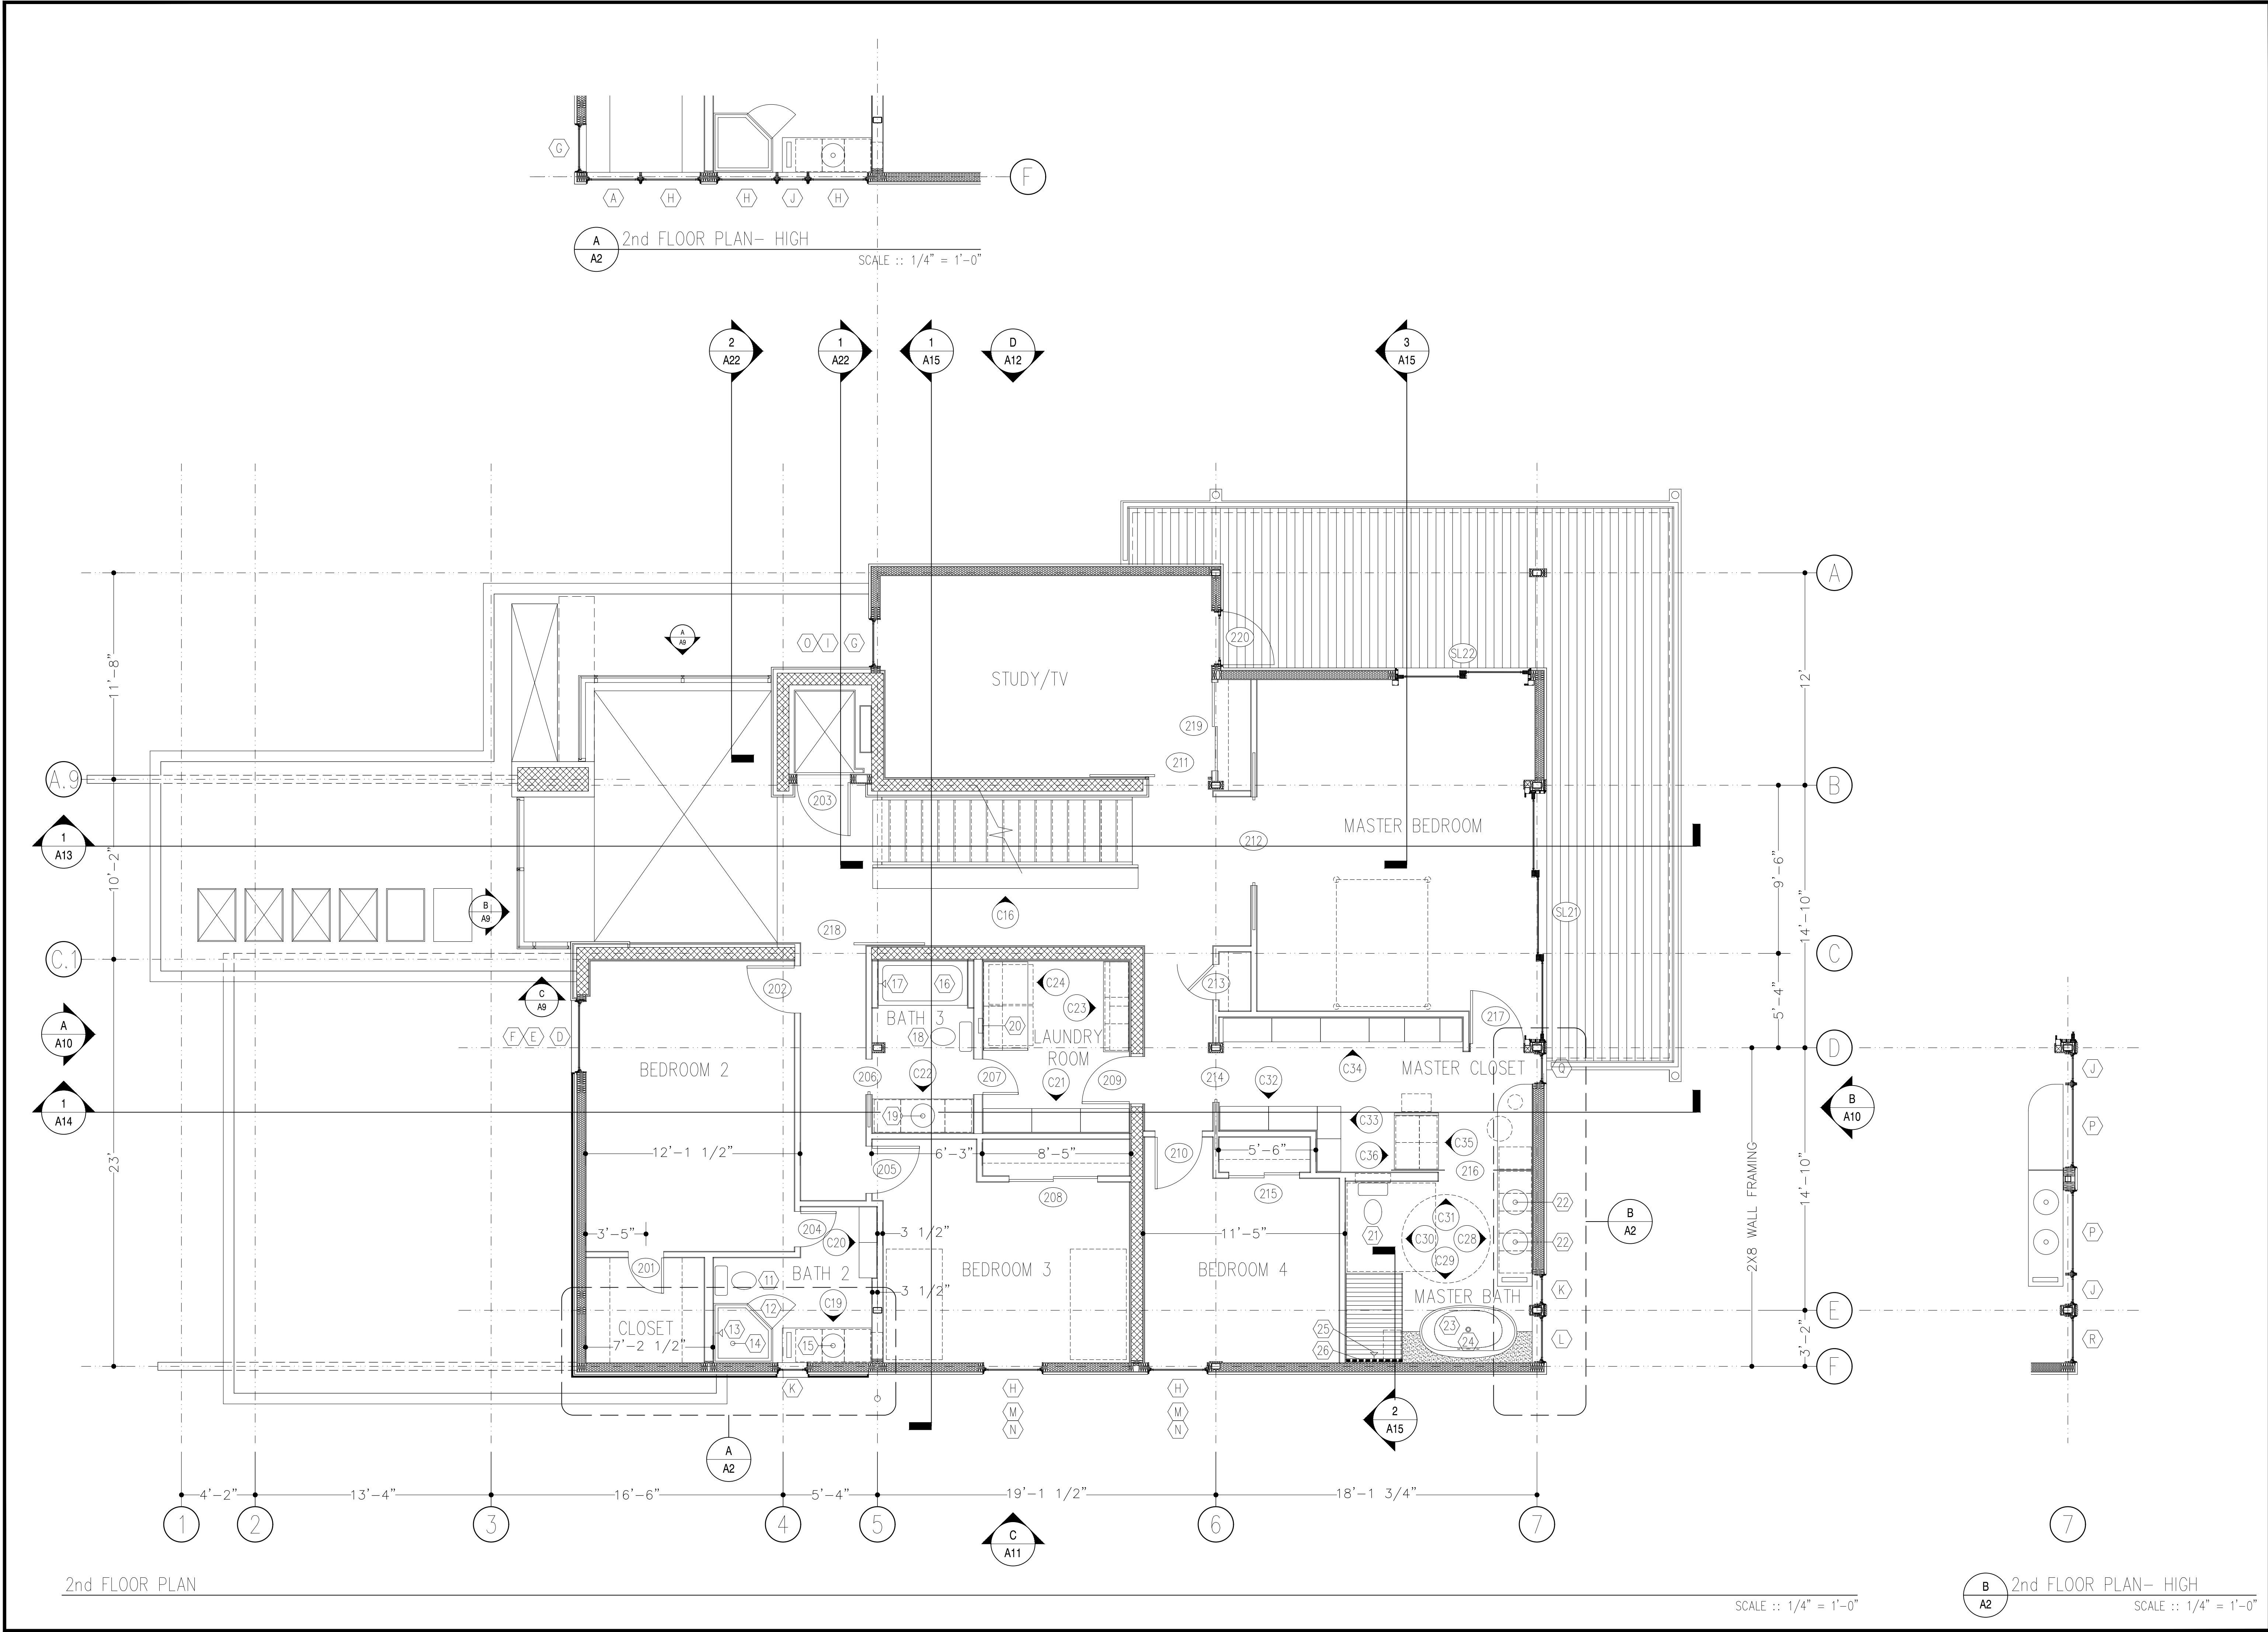

2nd FLOOR PLAN

SCALE :: 1/4" = 1'-0"

B
A2
2nd FLOOR PLAN- HIGH
SCALE :: 1/4" = 1'-0"



DEBBIE & MICHAEL ROSS RESIDENCE
2726 E OCEAN VIEW AVE

ISSUED FOR: MARK: DATE: 03-27-22
75% DESIGN

StudioRoss LLC
223 82nd Street
Virginia Beach, VA 23451
757-323-2209

2nd FLOOR PLAN


A2

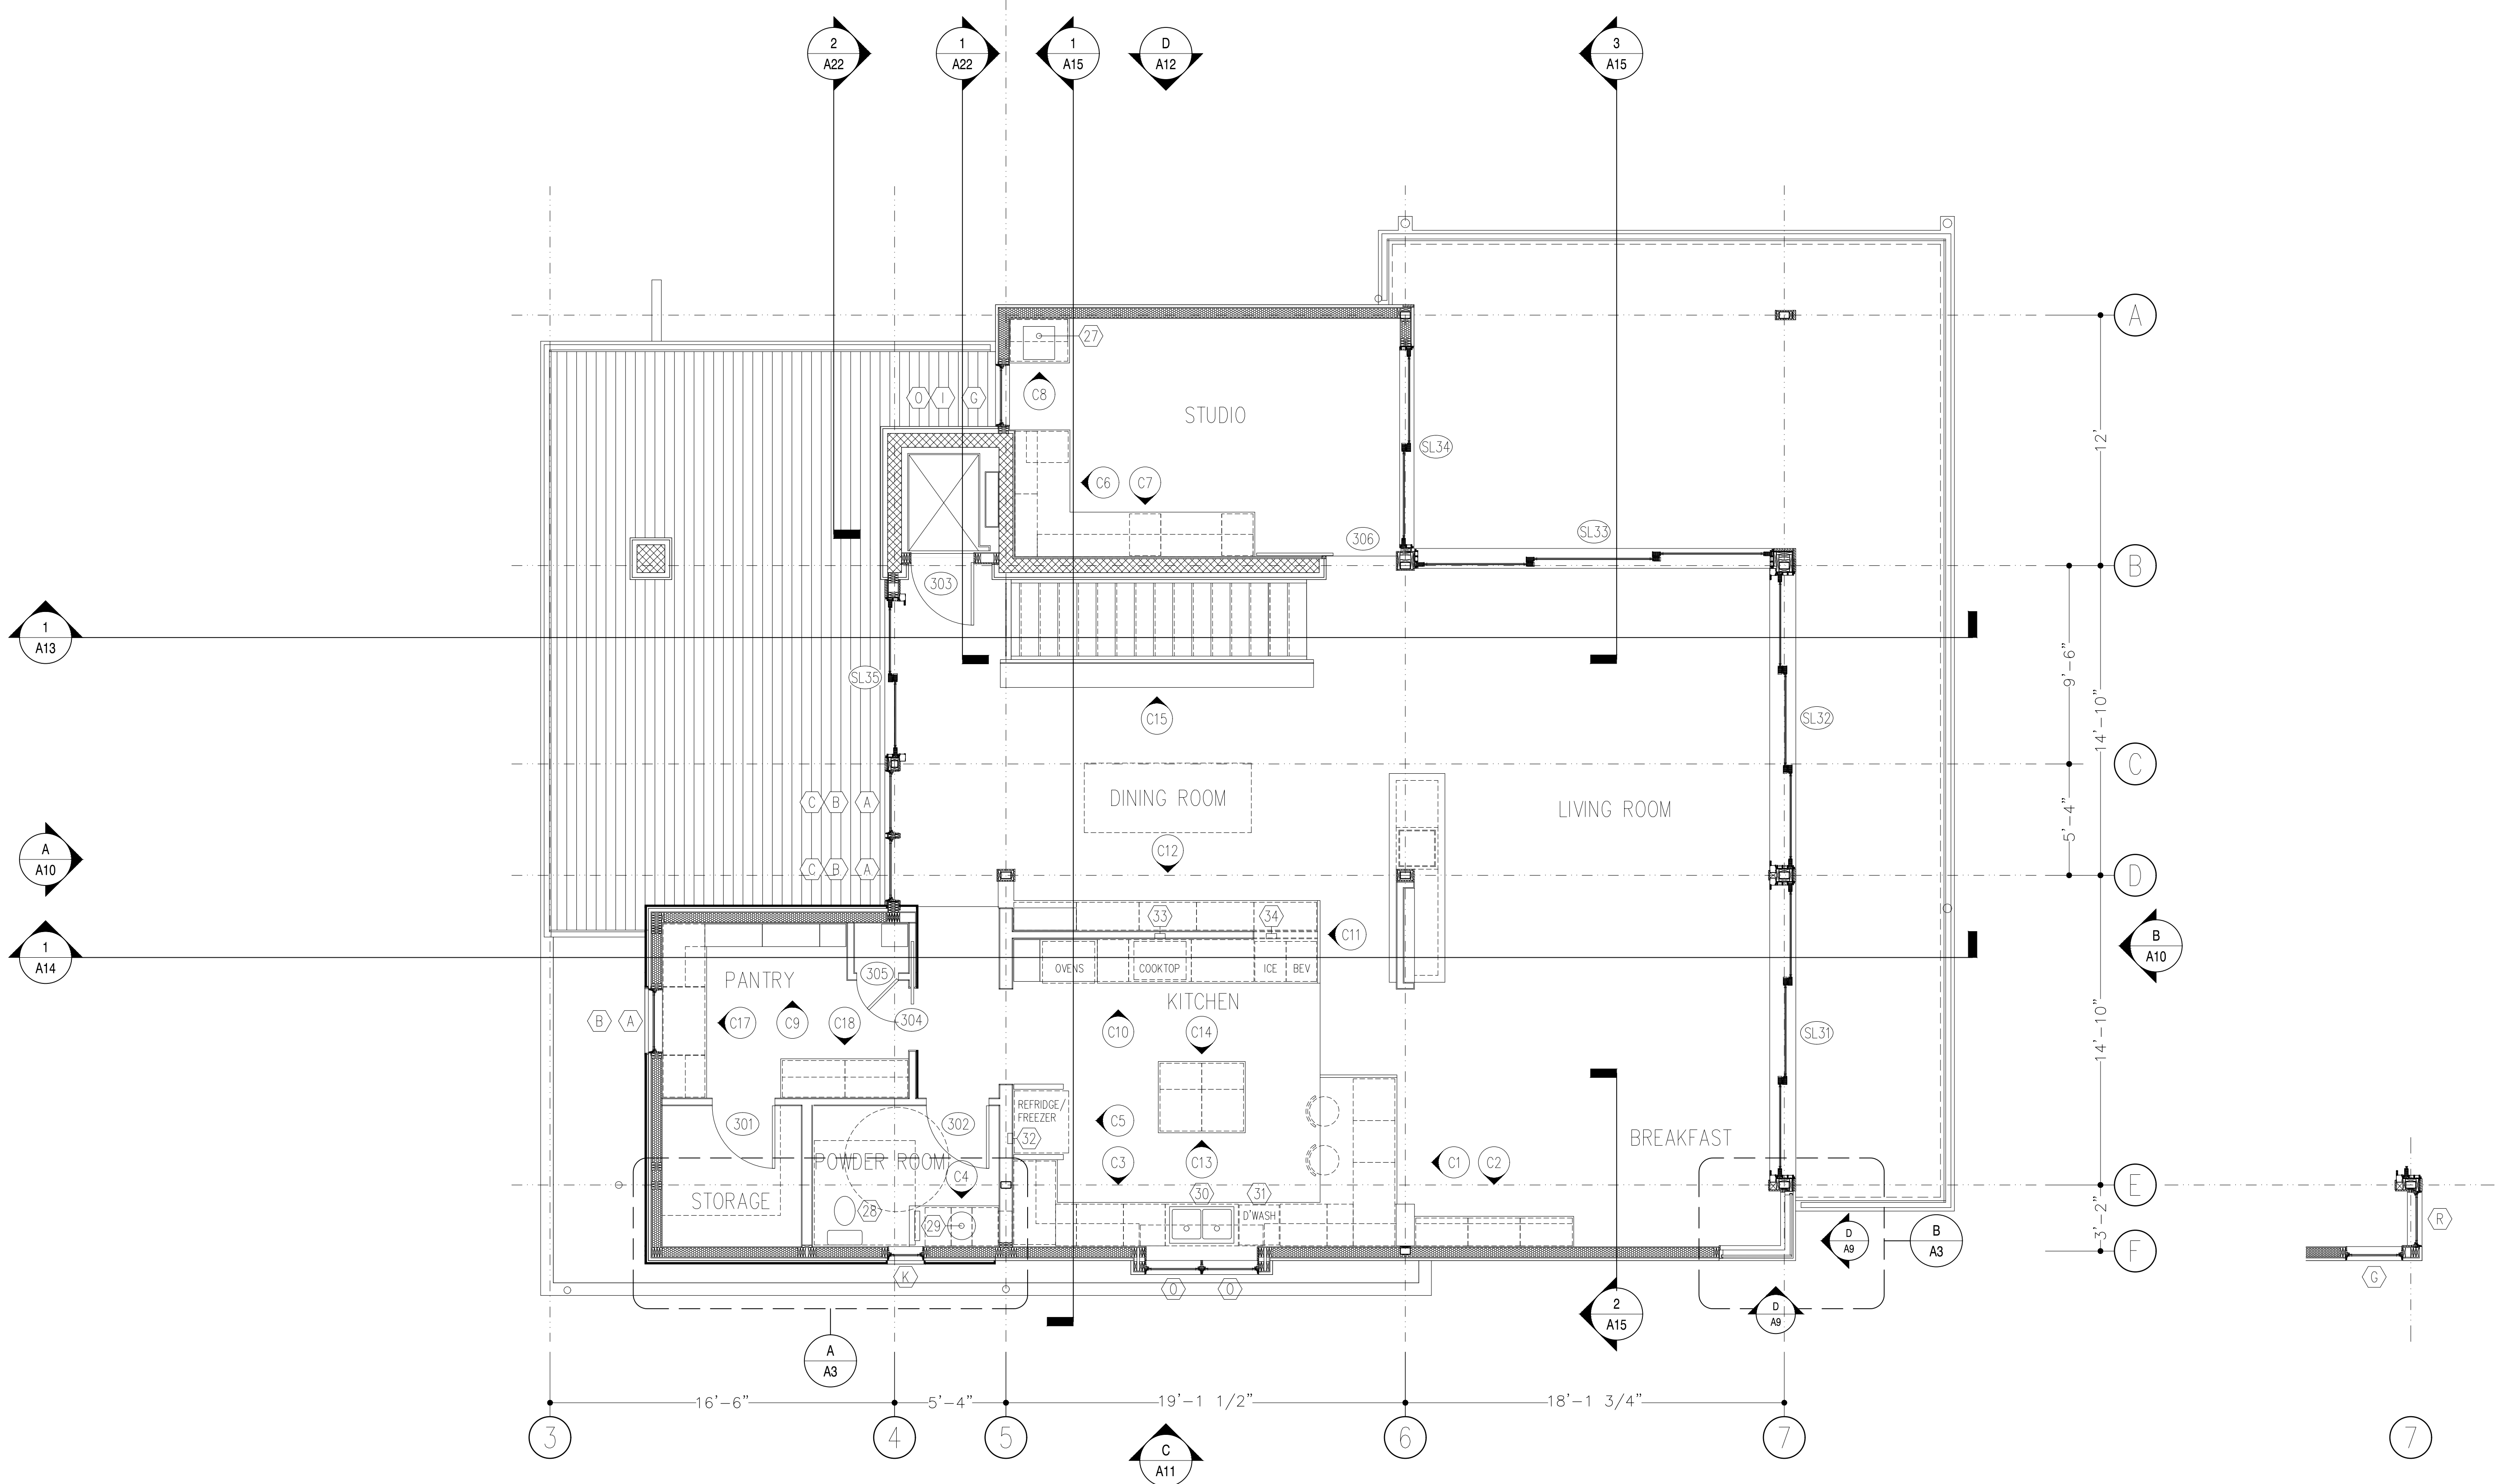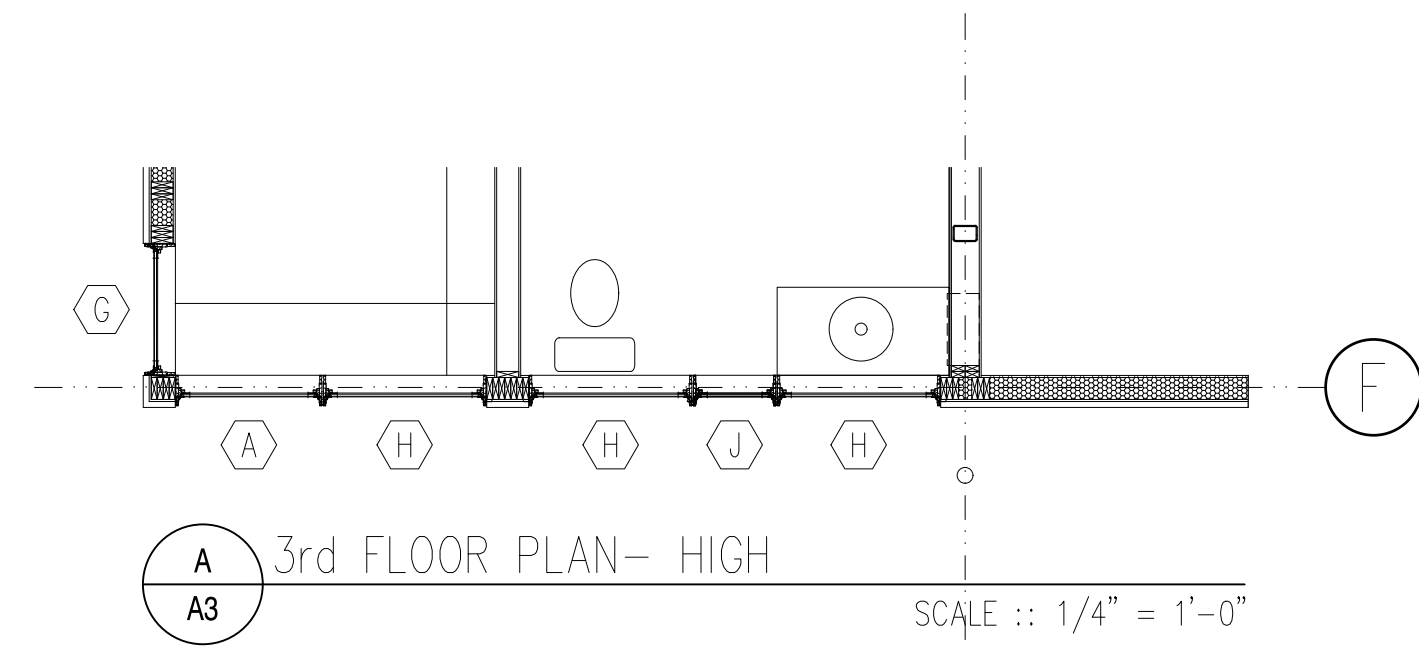

3rd FLOOR PLAN


SCALE :: 1/4" = 1'-0"



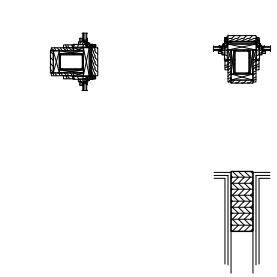

SCALE :: 1/4" = 1'-0"

A4

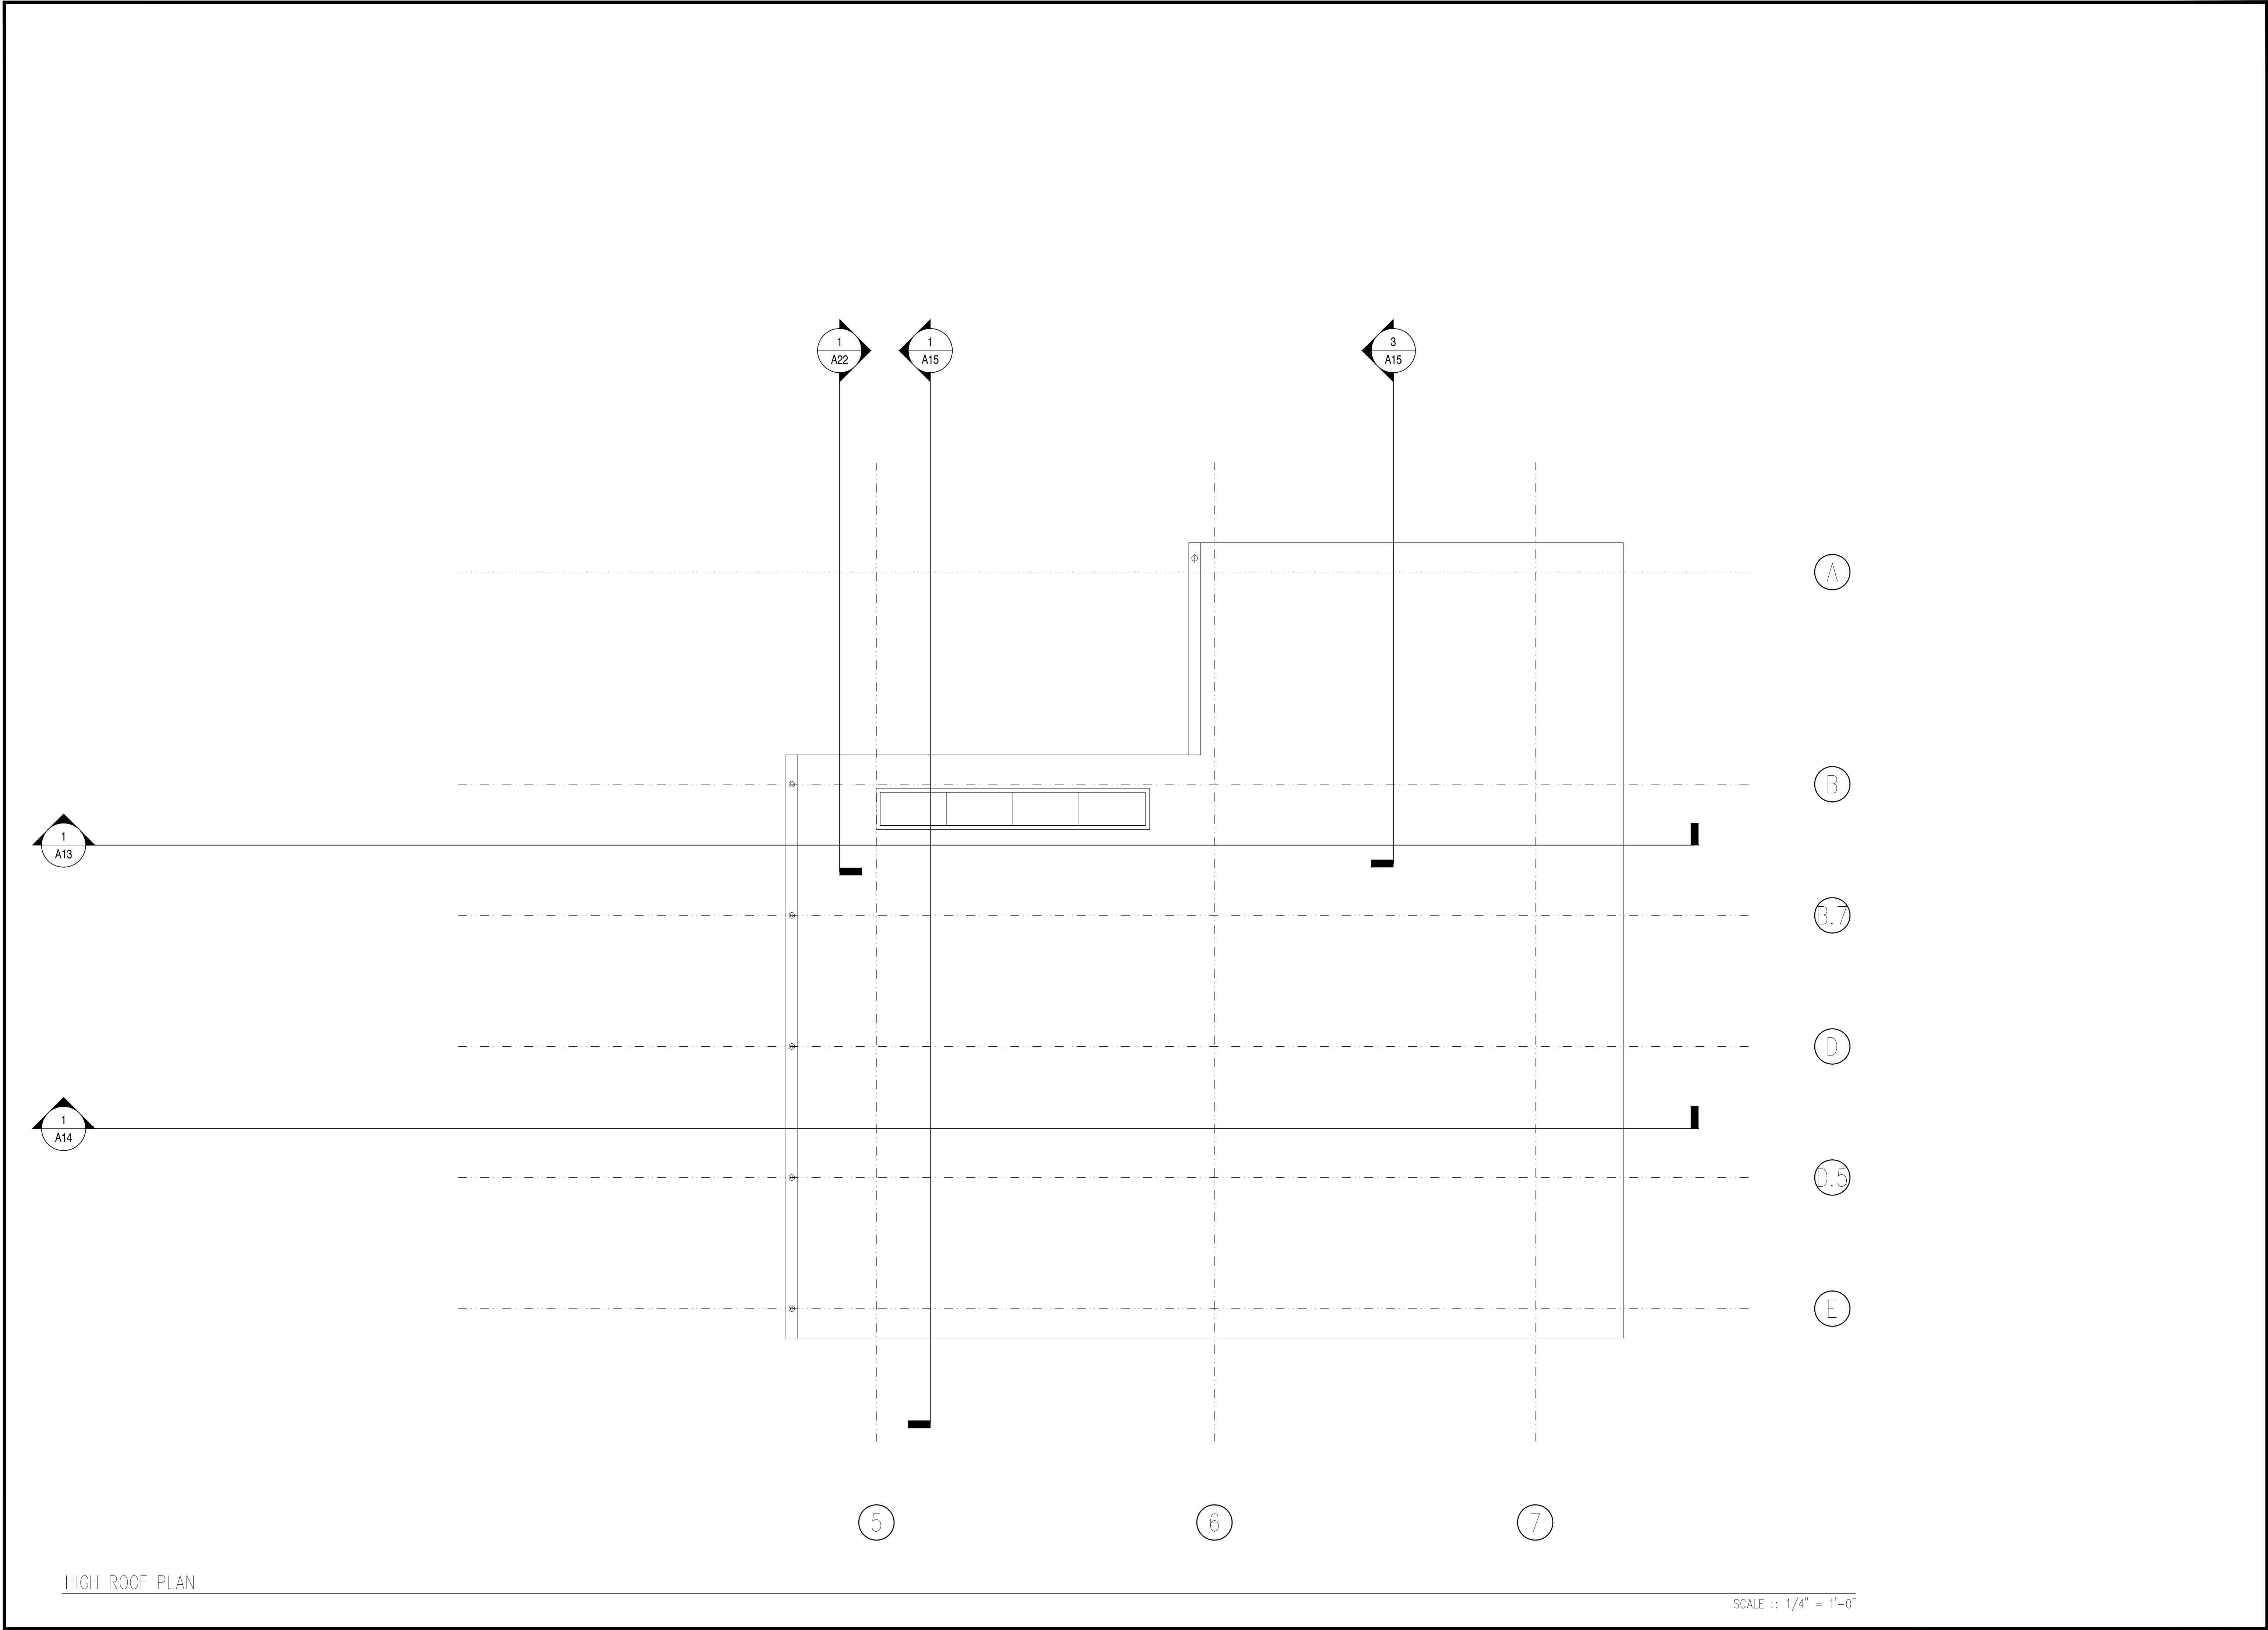


DEBBIE & MICHAEL ROSS RESIDENCE
2726 E OCEAN VIEW AVE

ISSUED FOR: 75% DESIGN
MARK: 03-27-22
DATE: 03-27-22

StudioRoss LLC
223 82nd Street
Virginia Beach, VA 23451
757-323-2209


HIGH ROOF PLAN

A5

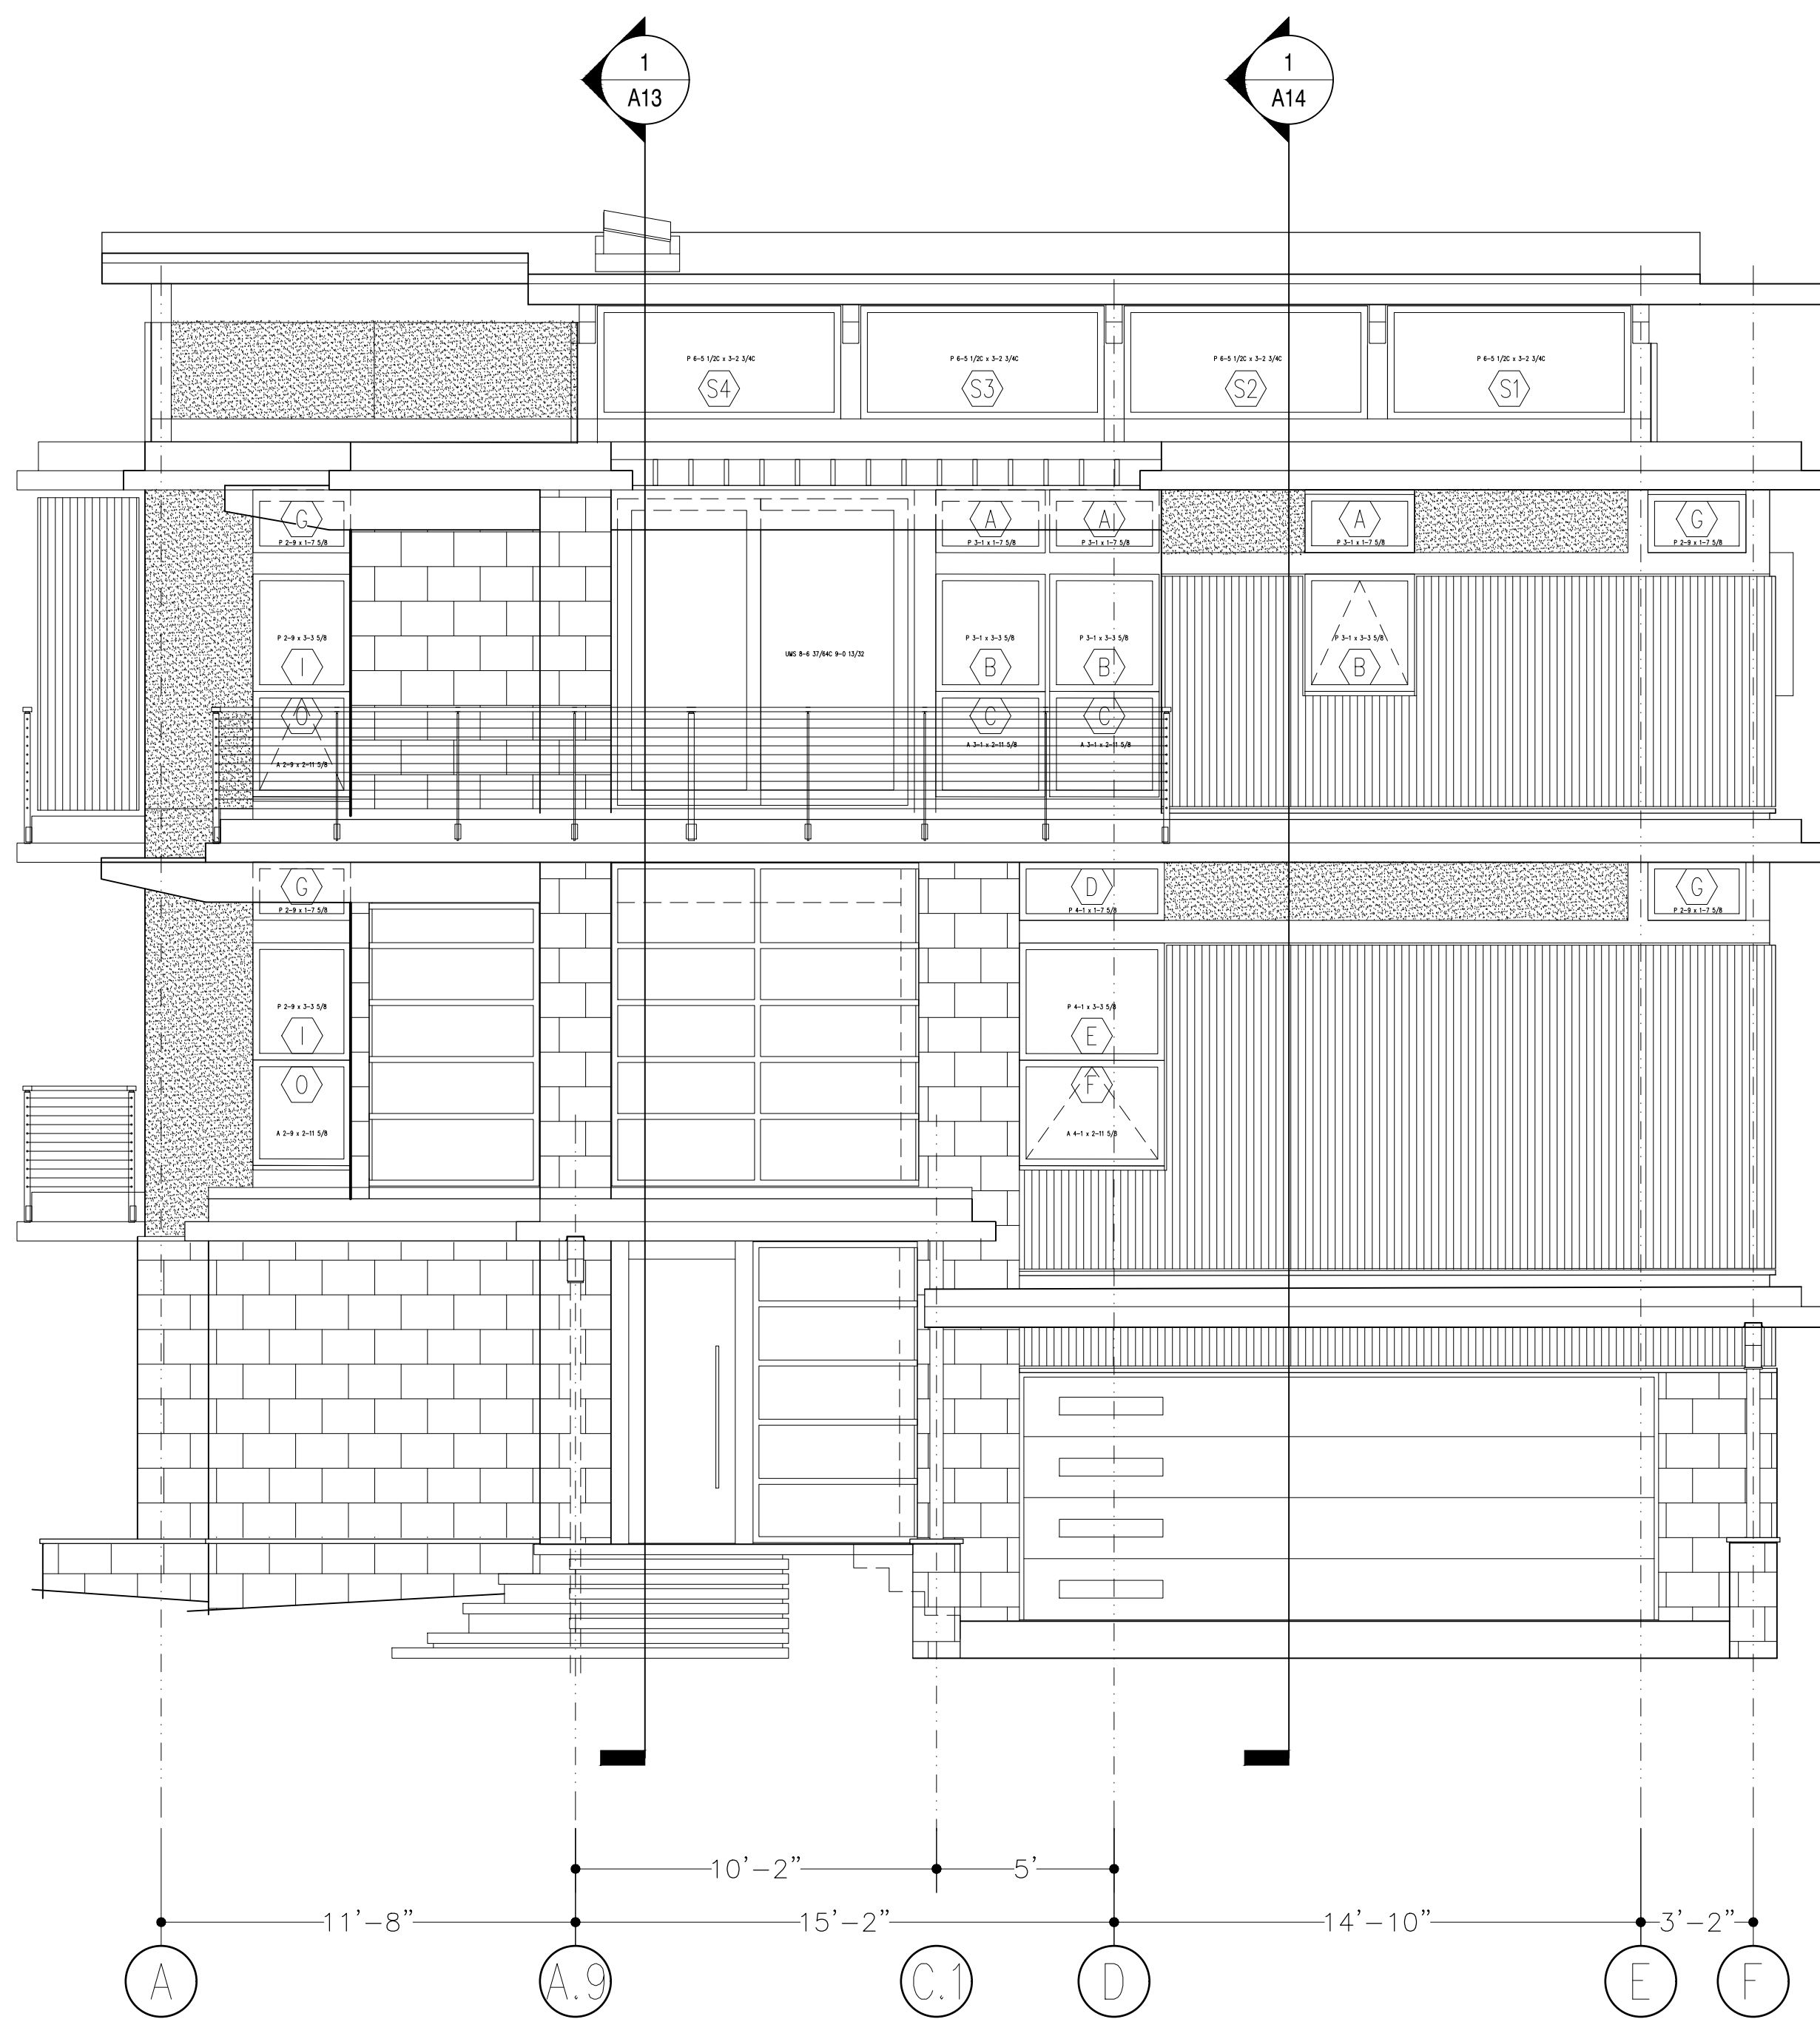

A SOUTH ELEVATION
A10

SCALE :: 1/4" = 1'-0"

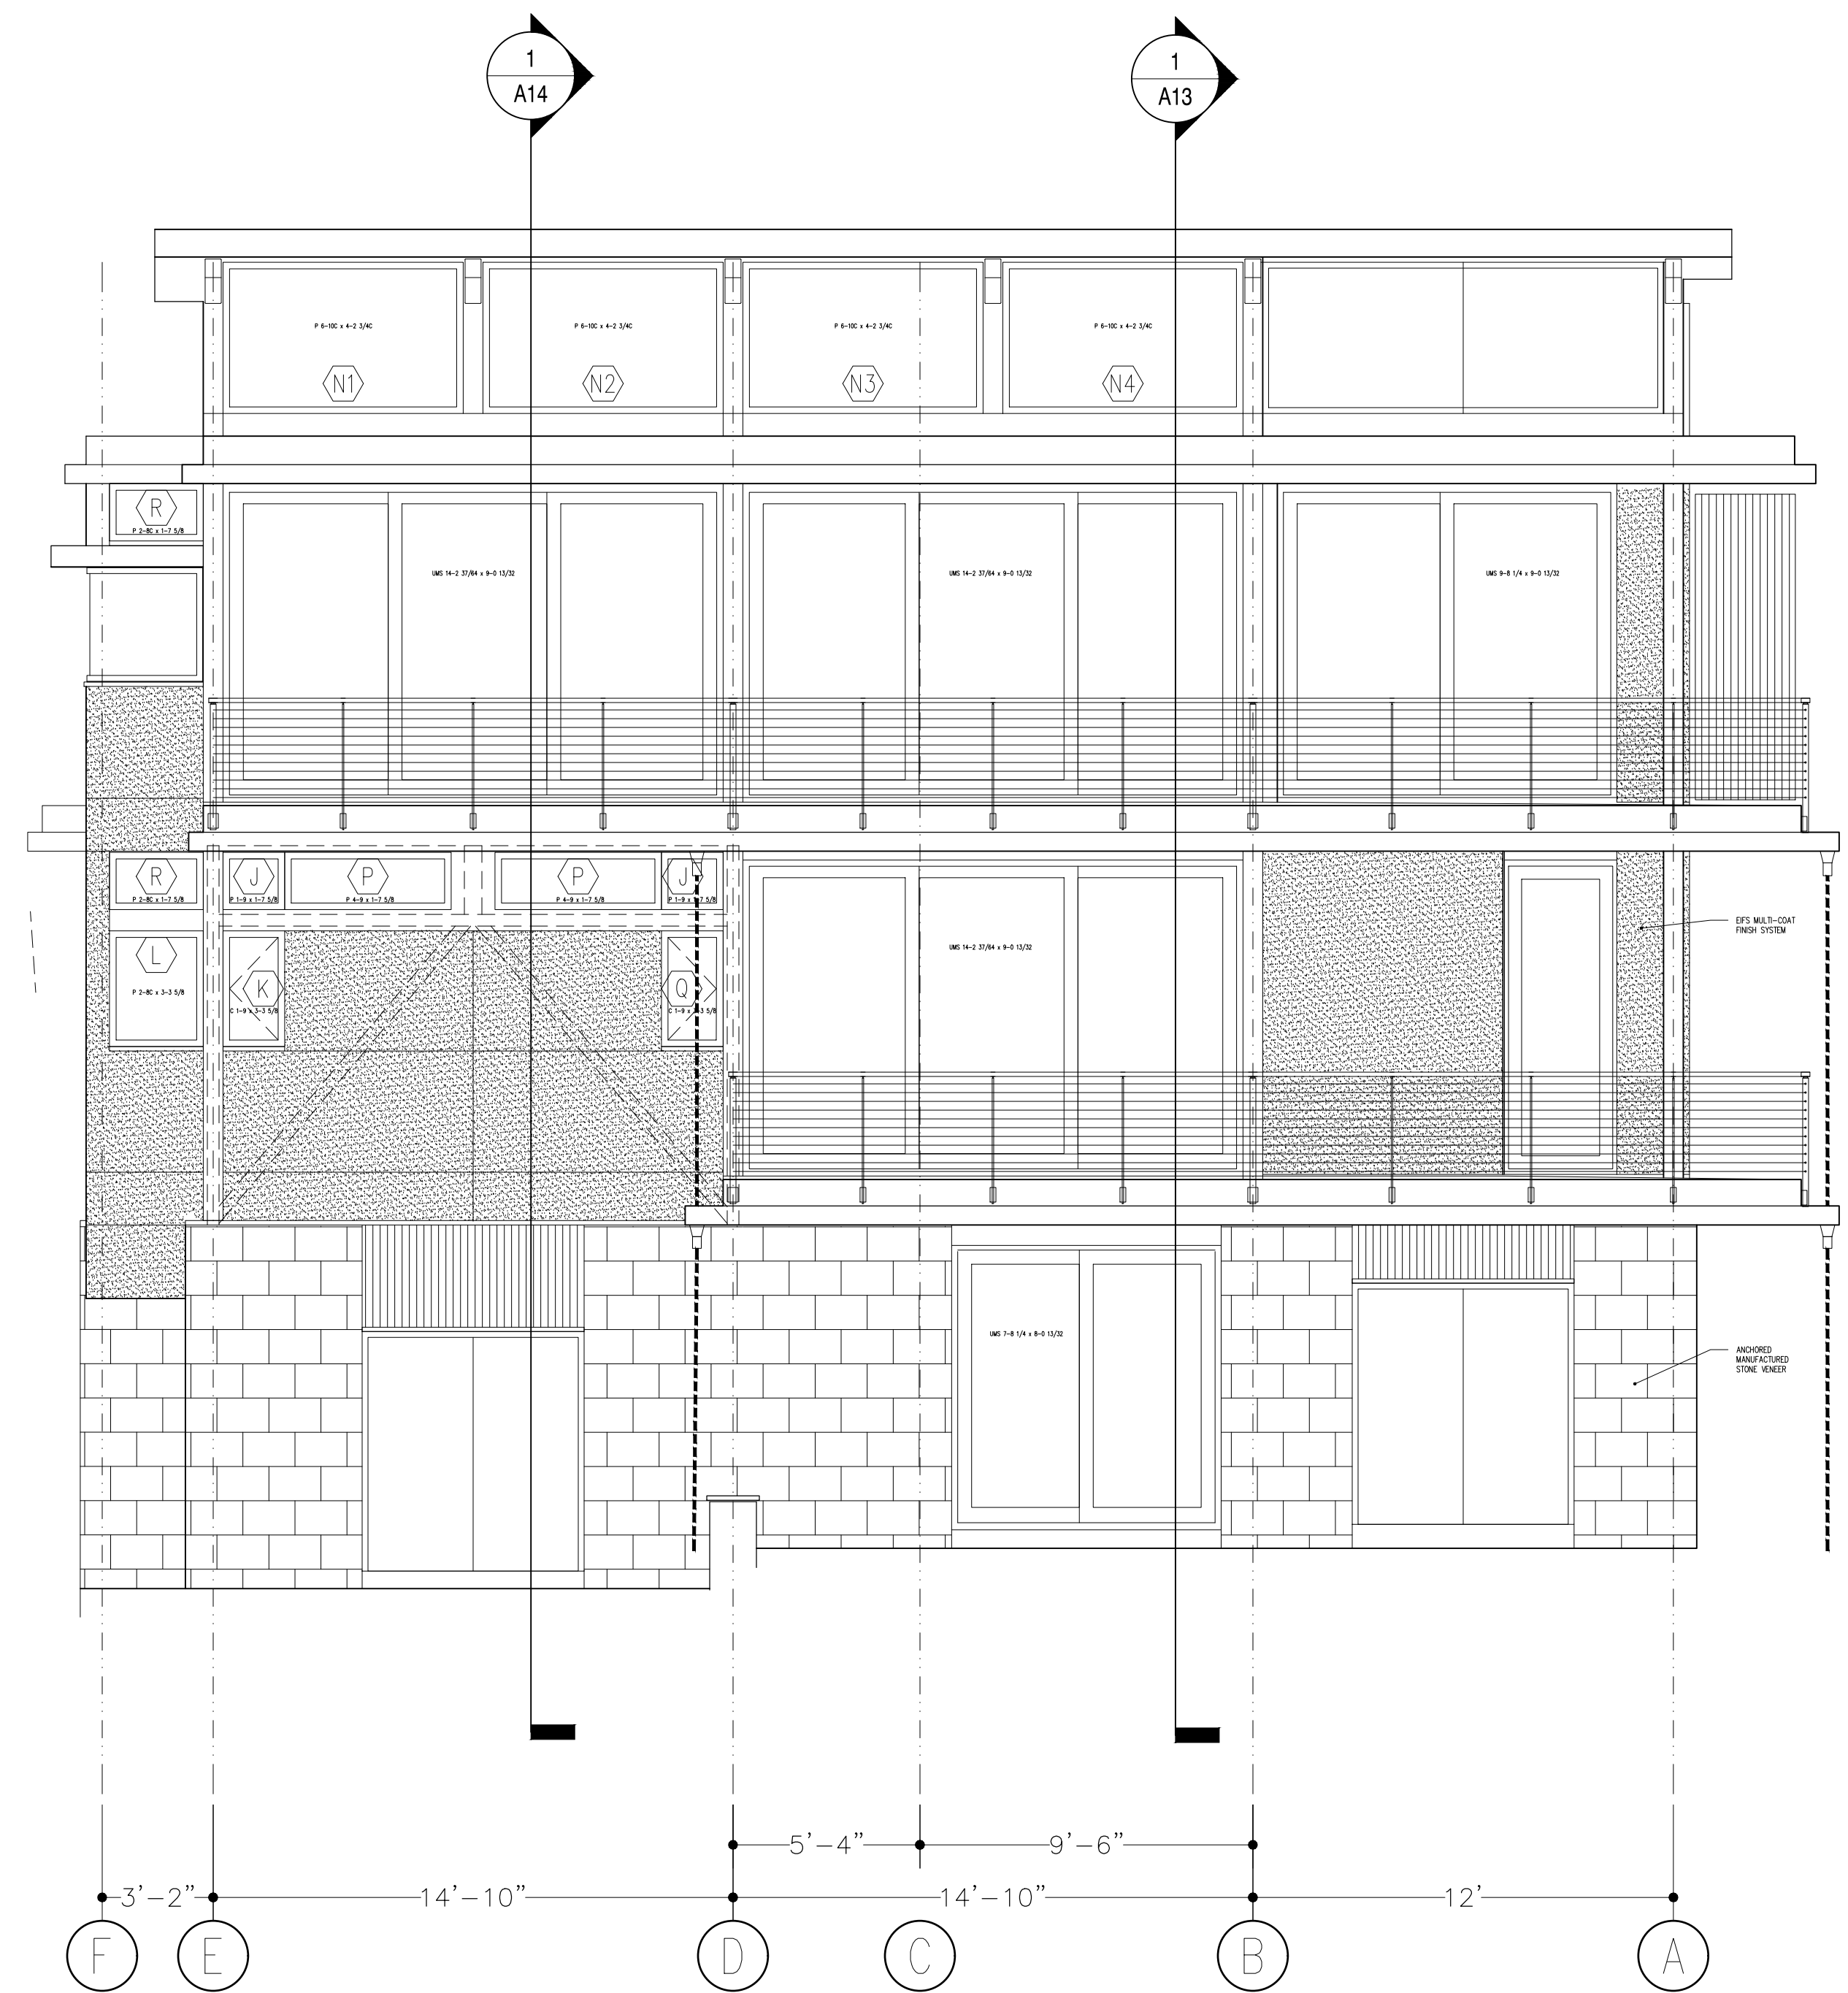

B NORTH ELEVATION
A10

SCALE :: 1/4" = 1'-0"


DEBBIE & MICHAEL ROSS RESIDENCE
2726 E OCEAN VIEW AVE

ISSUED FOR: MARK: DATE:
75% DESIGN 03-27-22

StudioRoss LLC
223 82nd Street
Virginia Beach, VA 23451
757-323-2209

SOUTH-NORTH
ELEVATIONS

A10

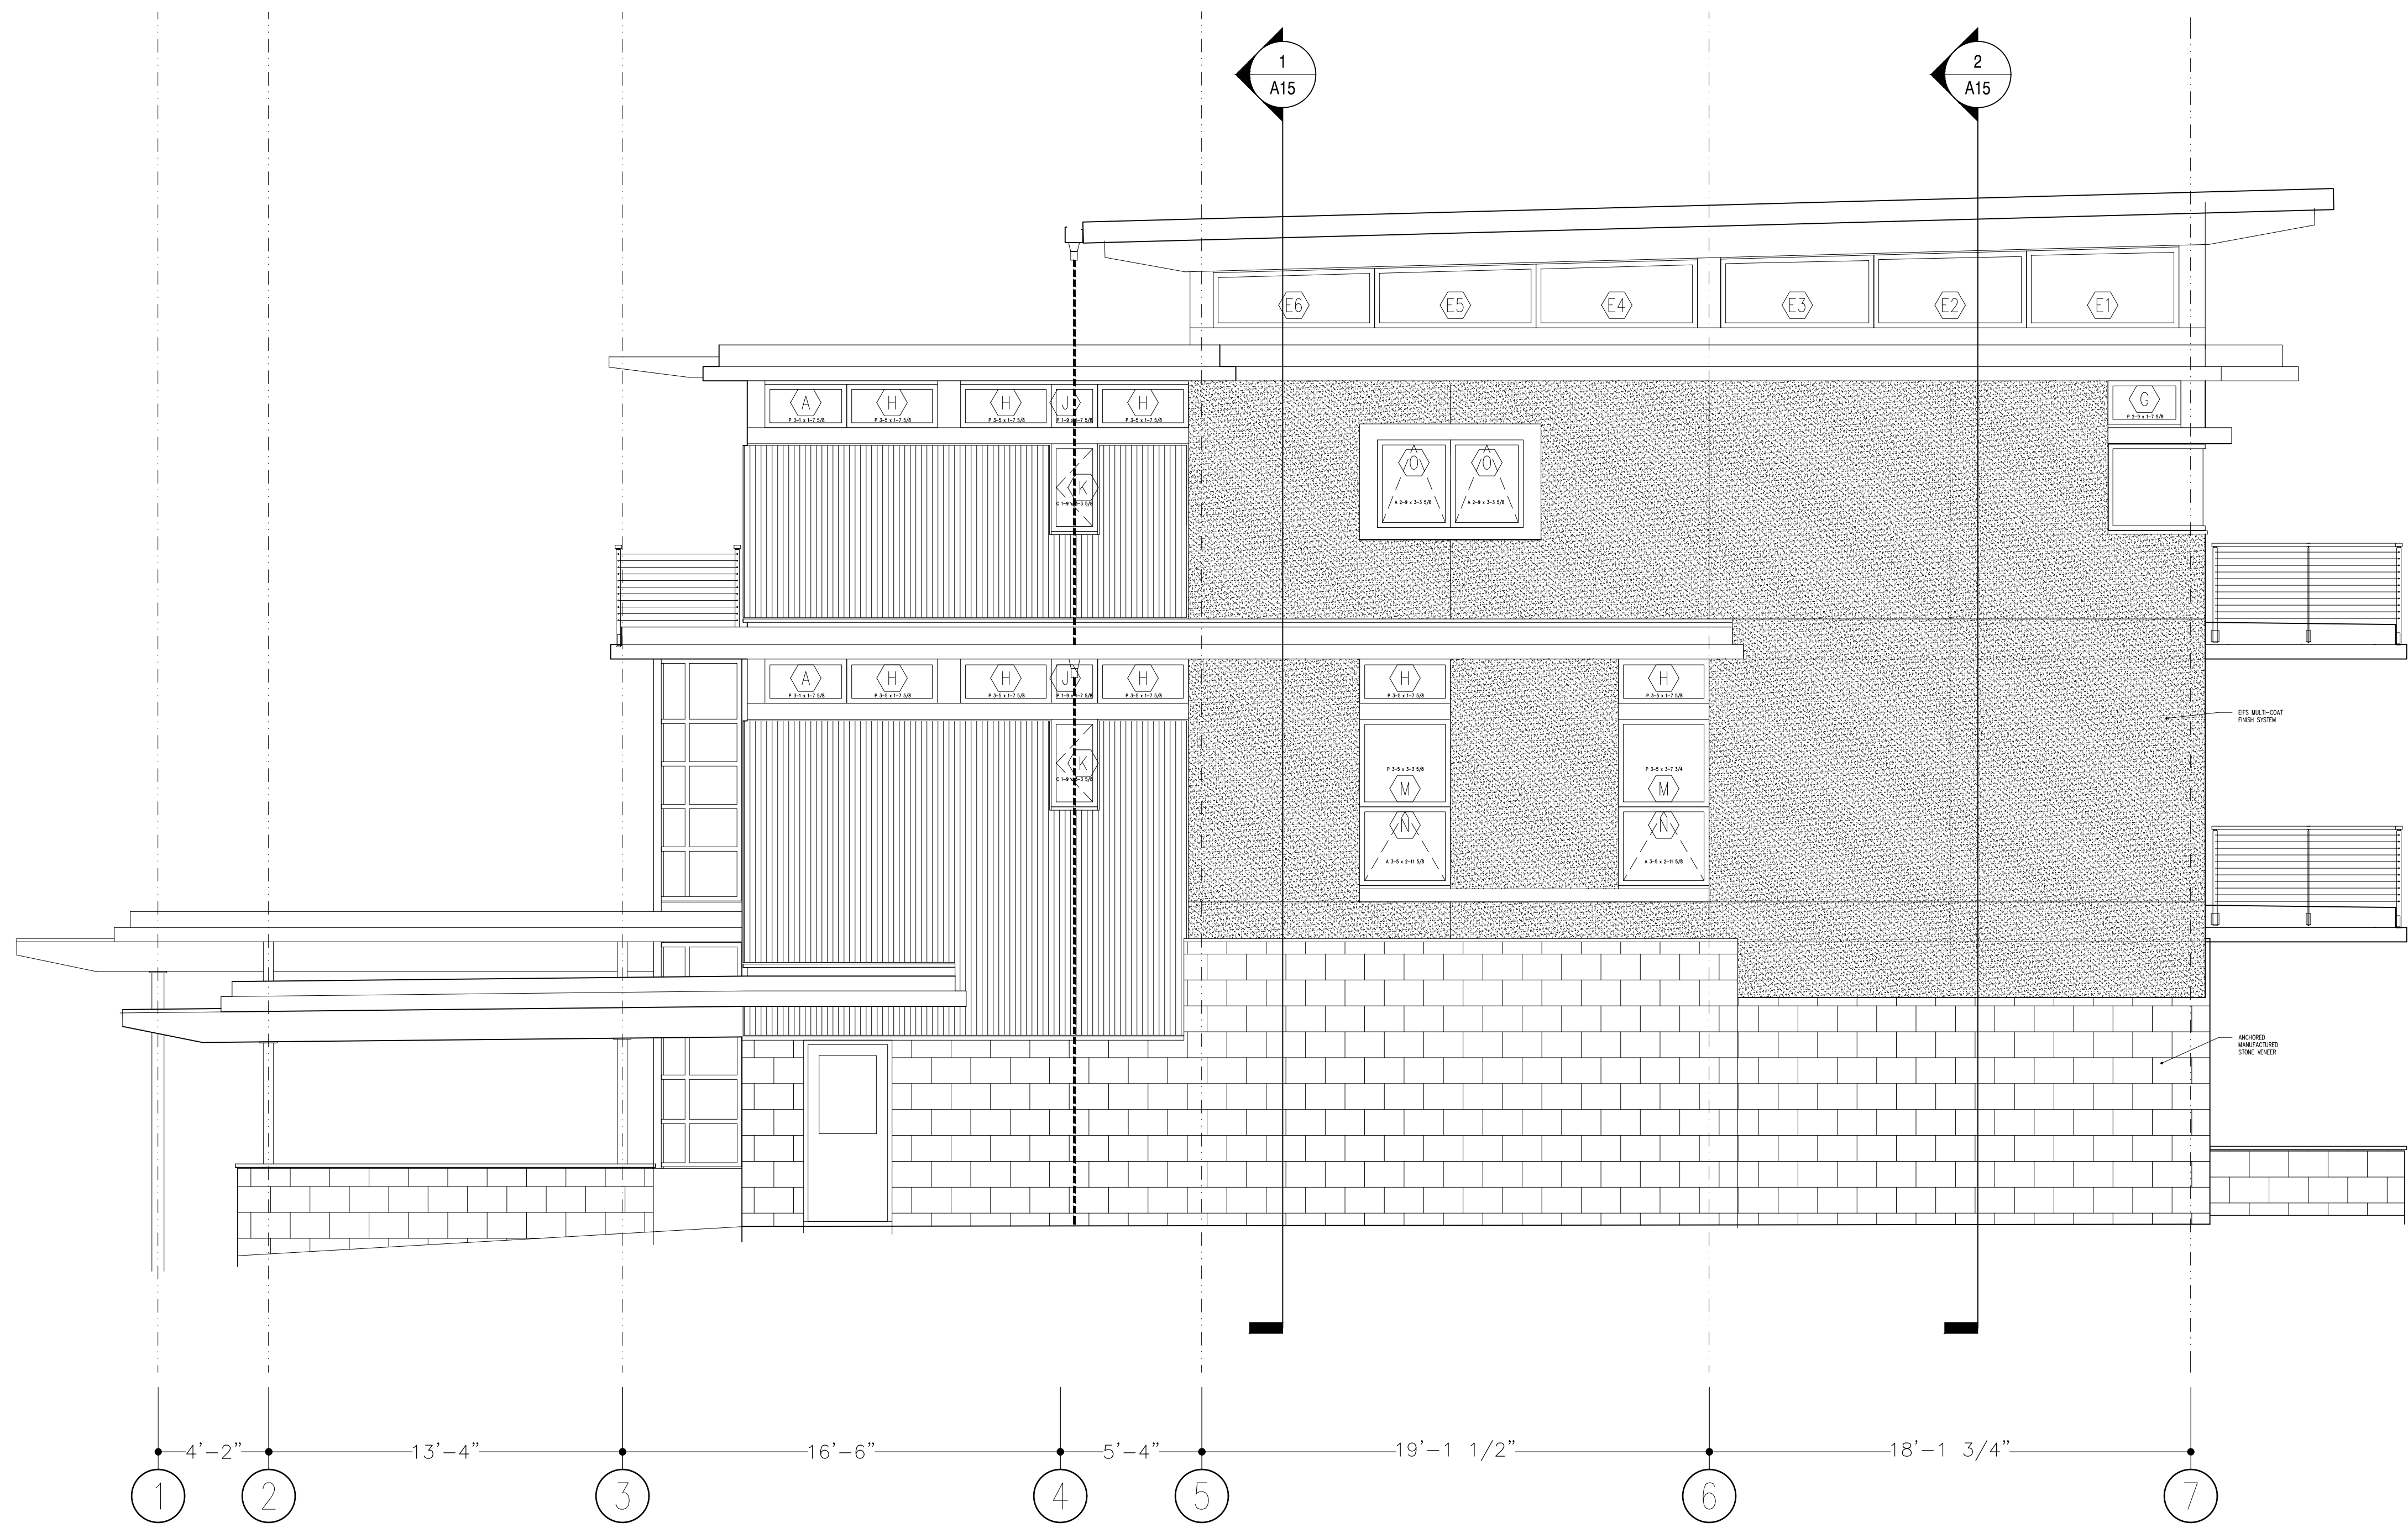

C
A11 EAST ELEVATION

SCALE :: 1/4" = 1'-0"


DEBBIE & MICHAEL ROSS RESIDENCE
2726 E OCEAN VIEW AVE

ISSUED FOR:	MARK:	DATE:
75% DESIGN		03-27-22

StudioRoss LLC
223 82nd Street
Virginia Beach, VA 23451
757-323-2209

EAST ELEVATION

A11

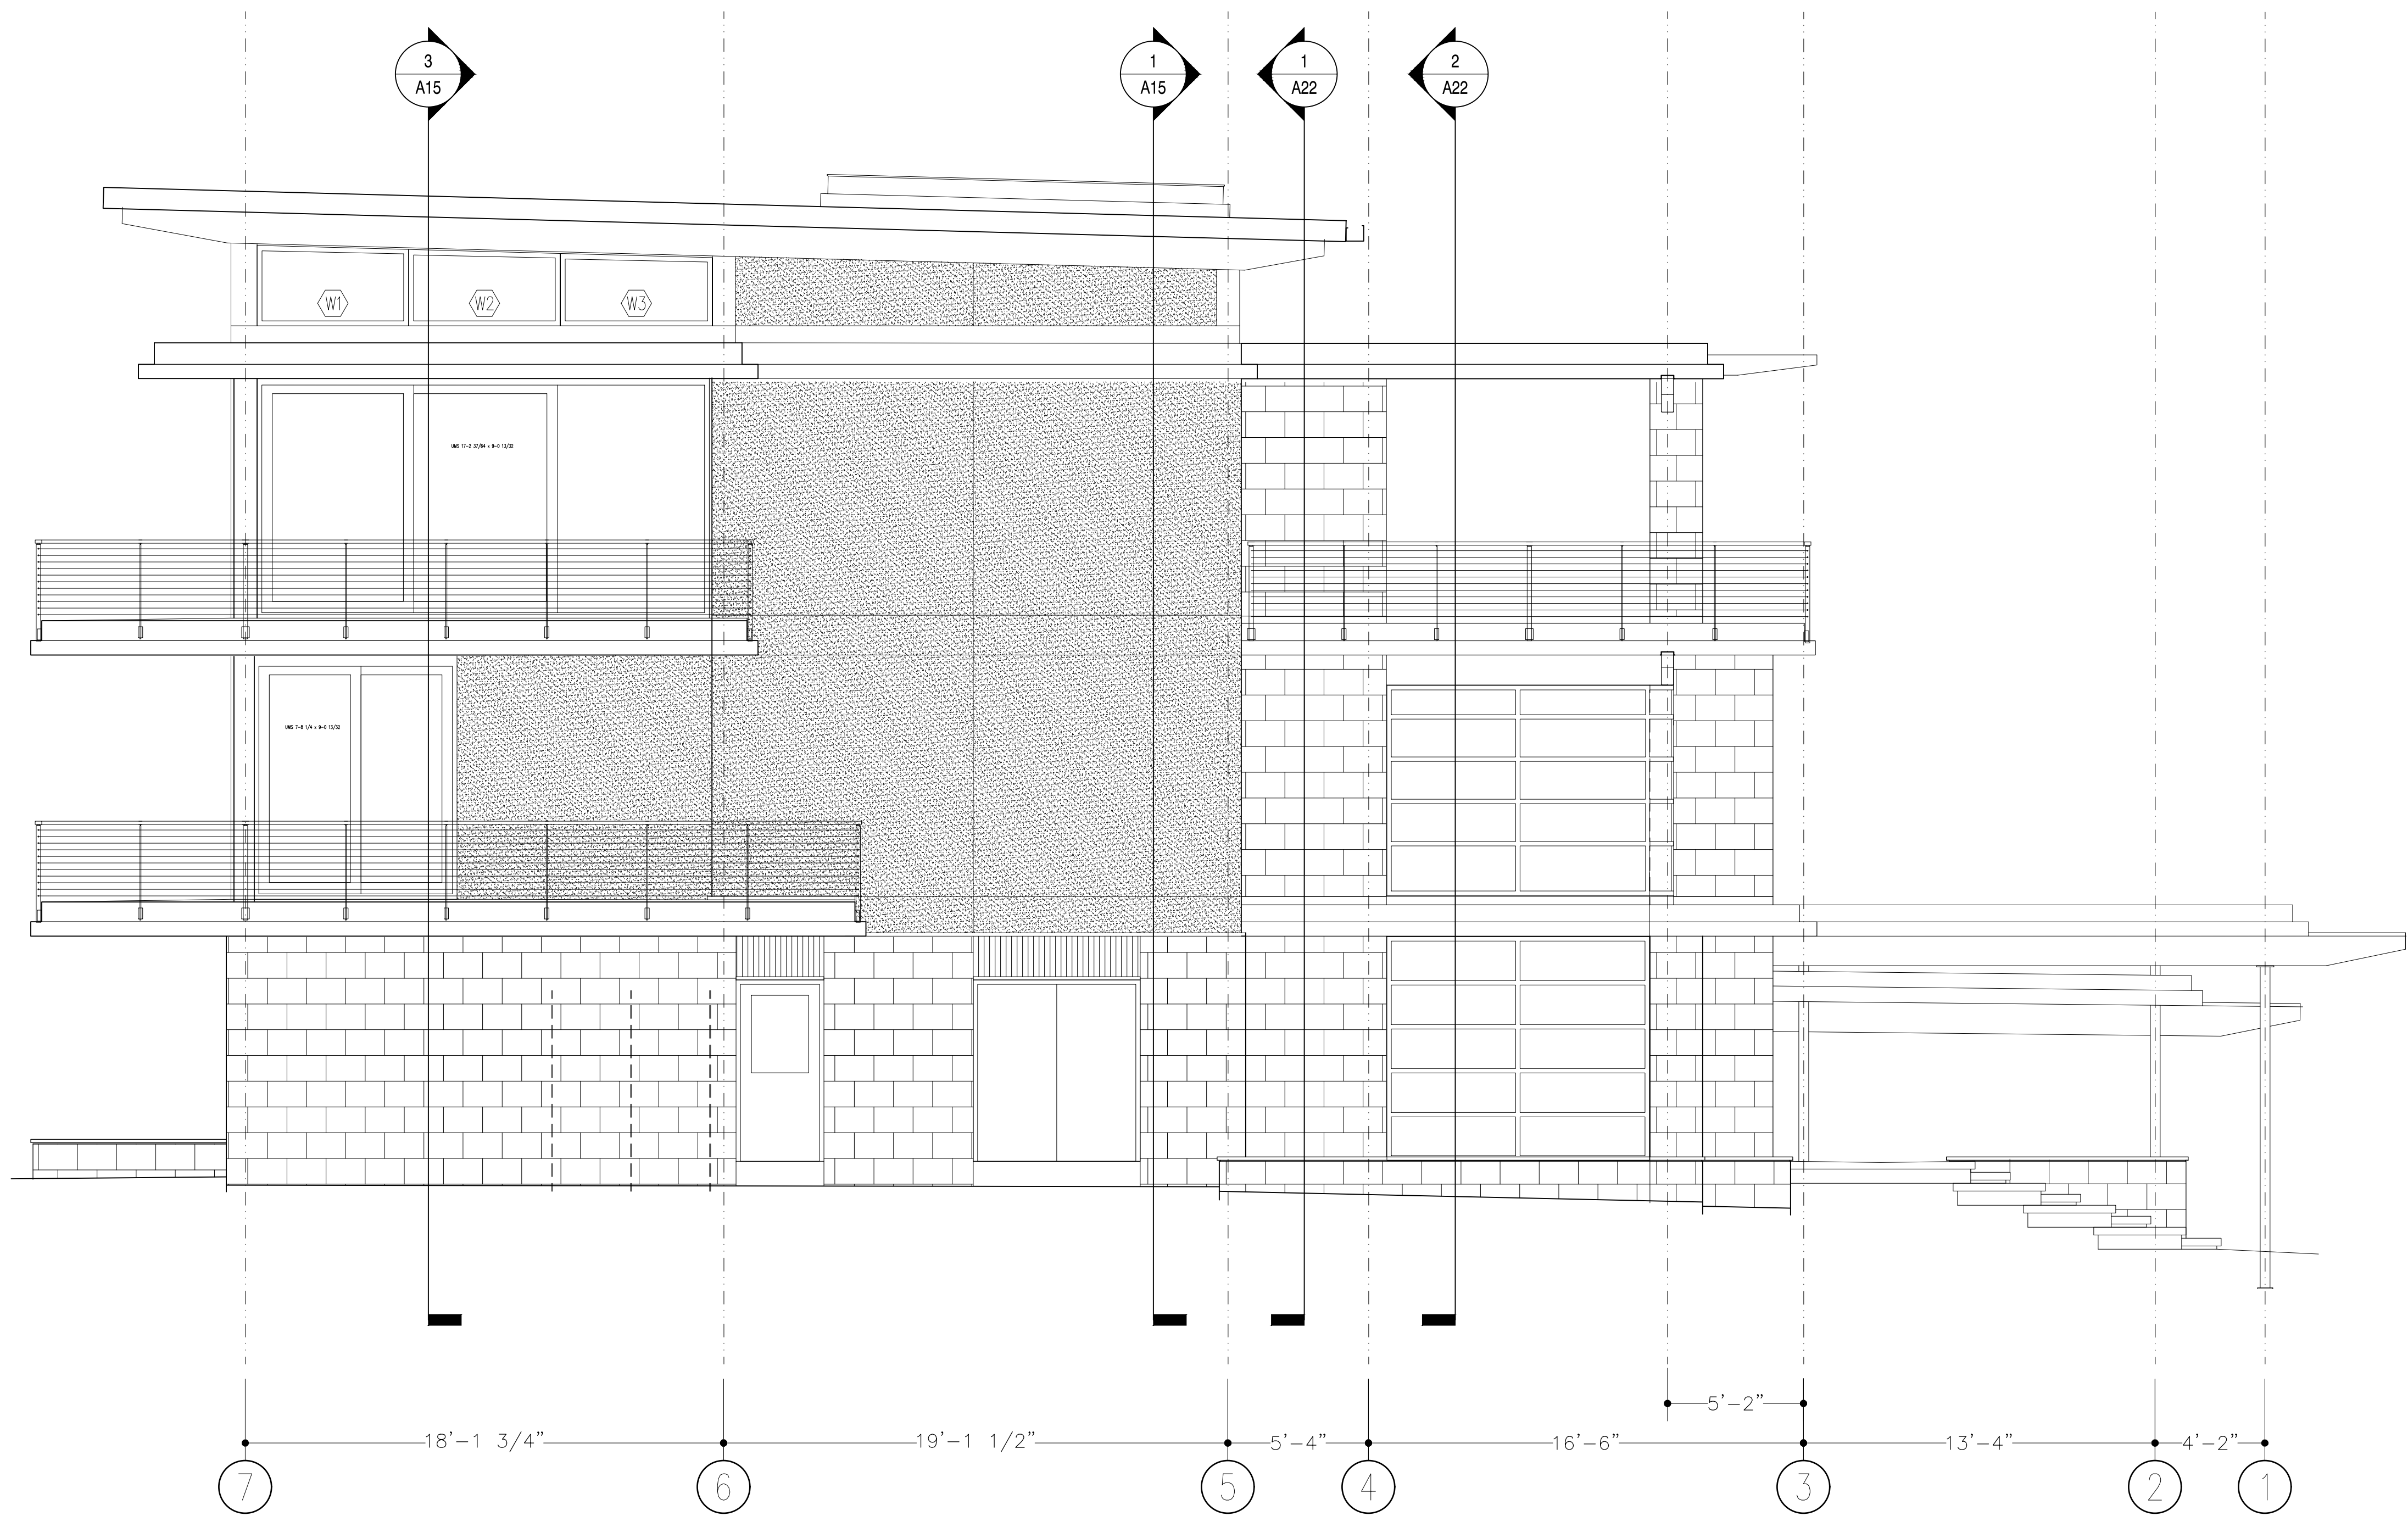

SCALE :: 1/4" = 1'-0"


DEBBIE & MICHAEL ROSS RESIDENCE
2726 E OCEAN VIEW AVE


ISSUED FOR: 75% DESIGN
MARK: 03-27-22
DATE:


StudioRoss LLC
223 82nd Street
Virginia Beach, VA 23451
757-323-2209

WEST ELEVATION

A12

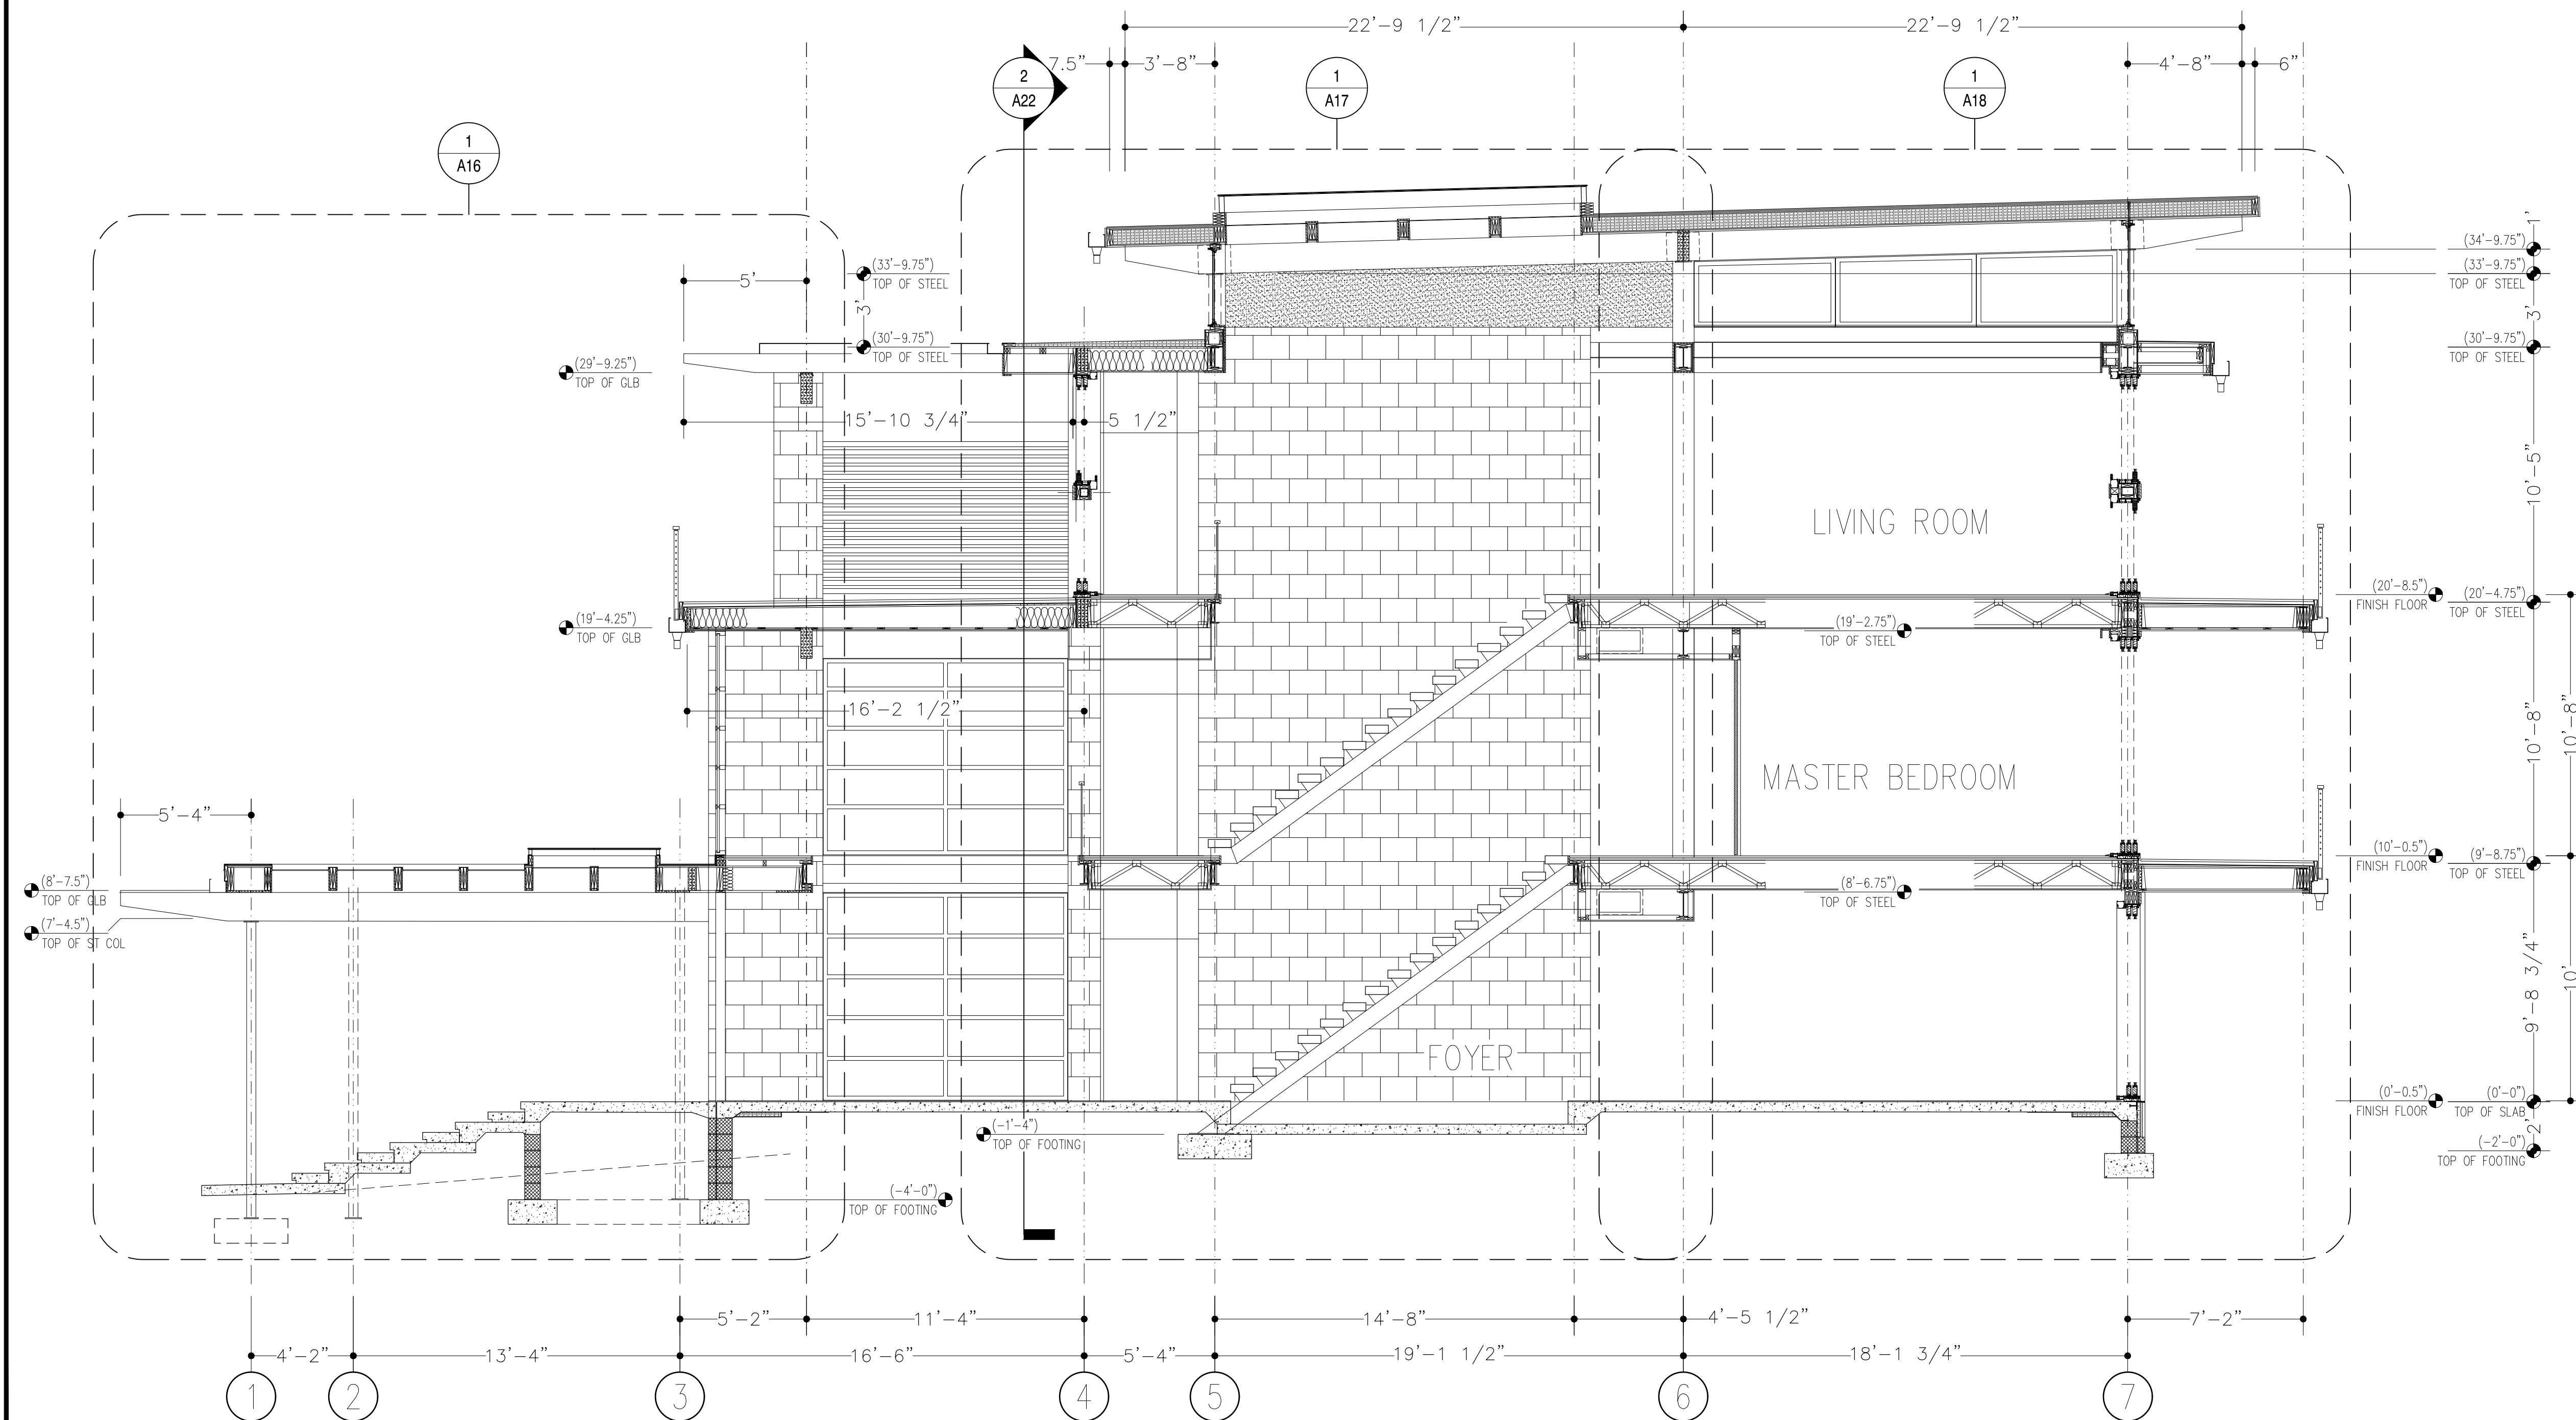

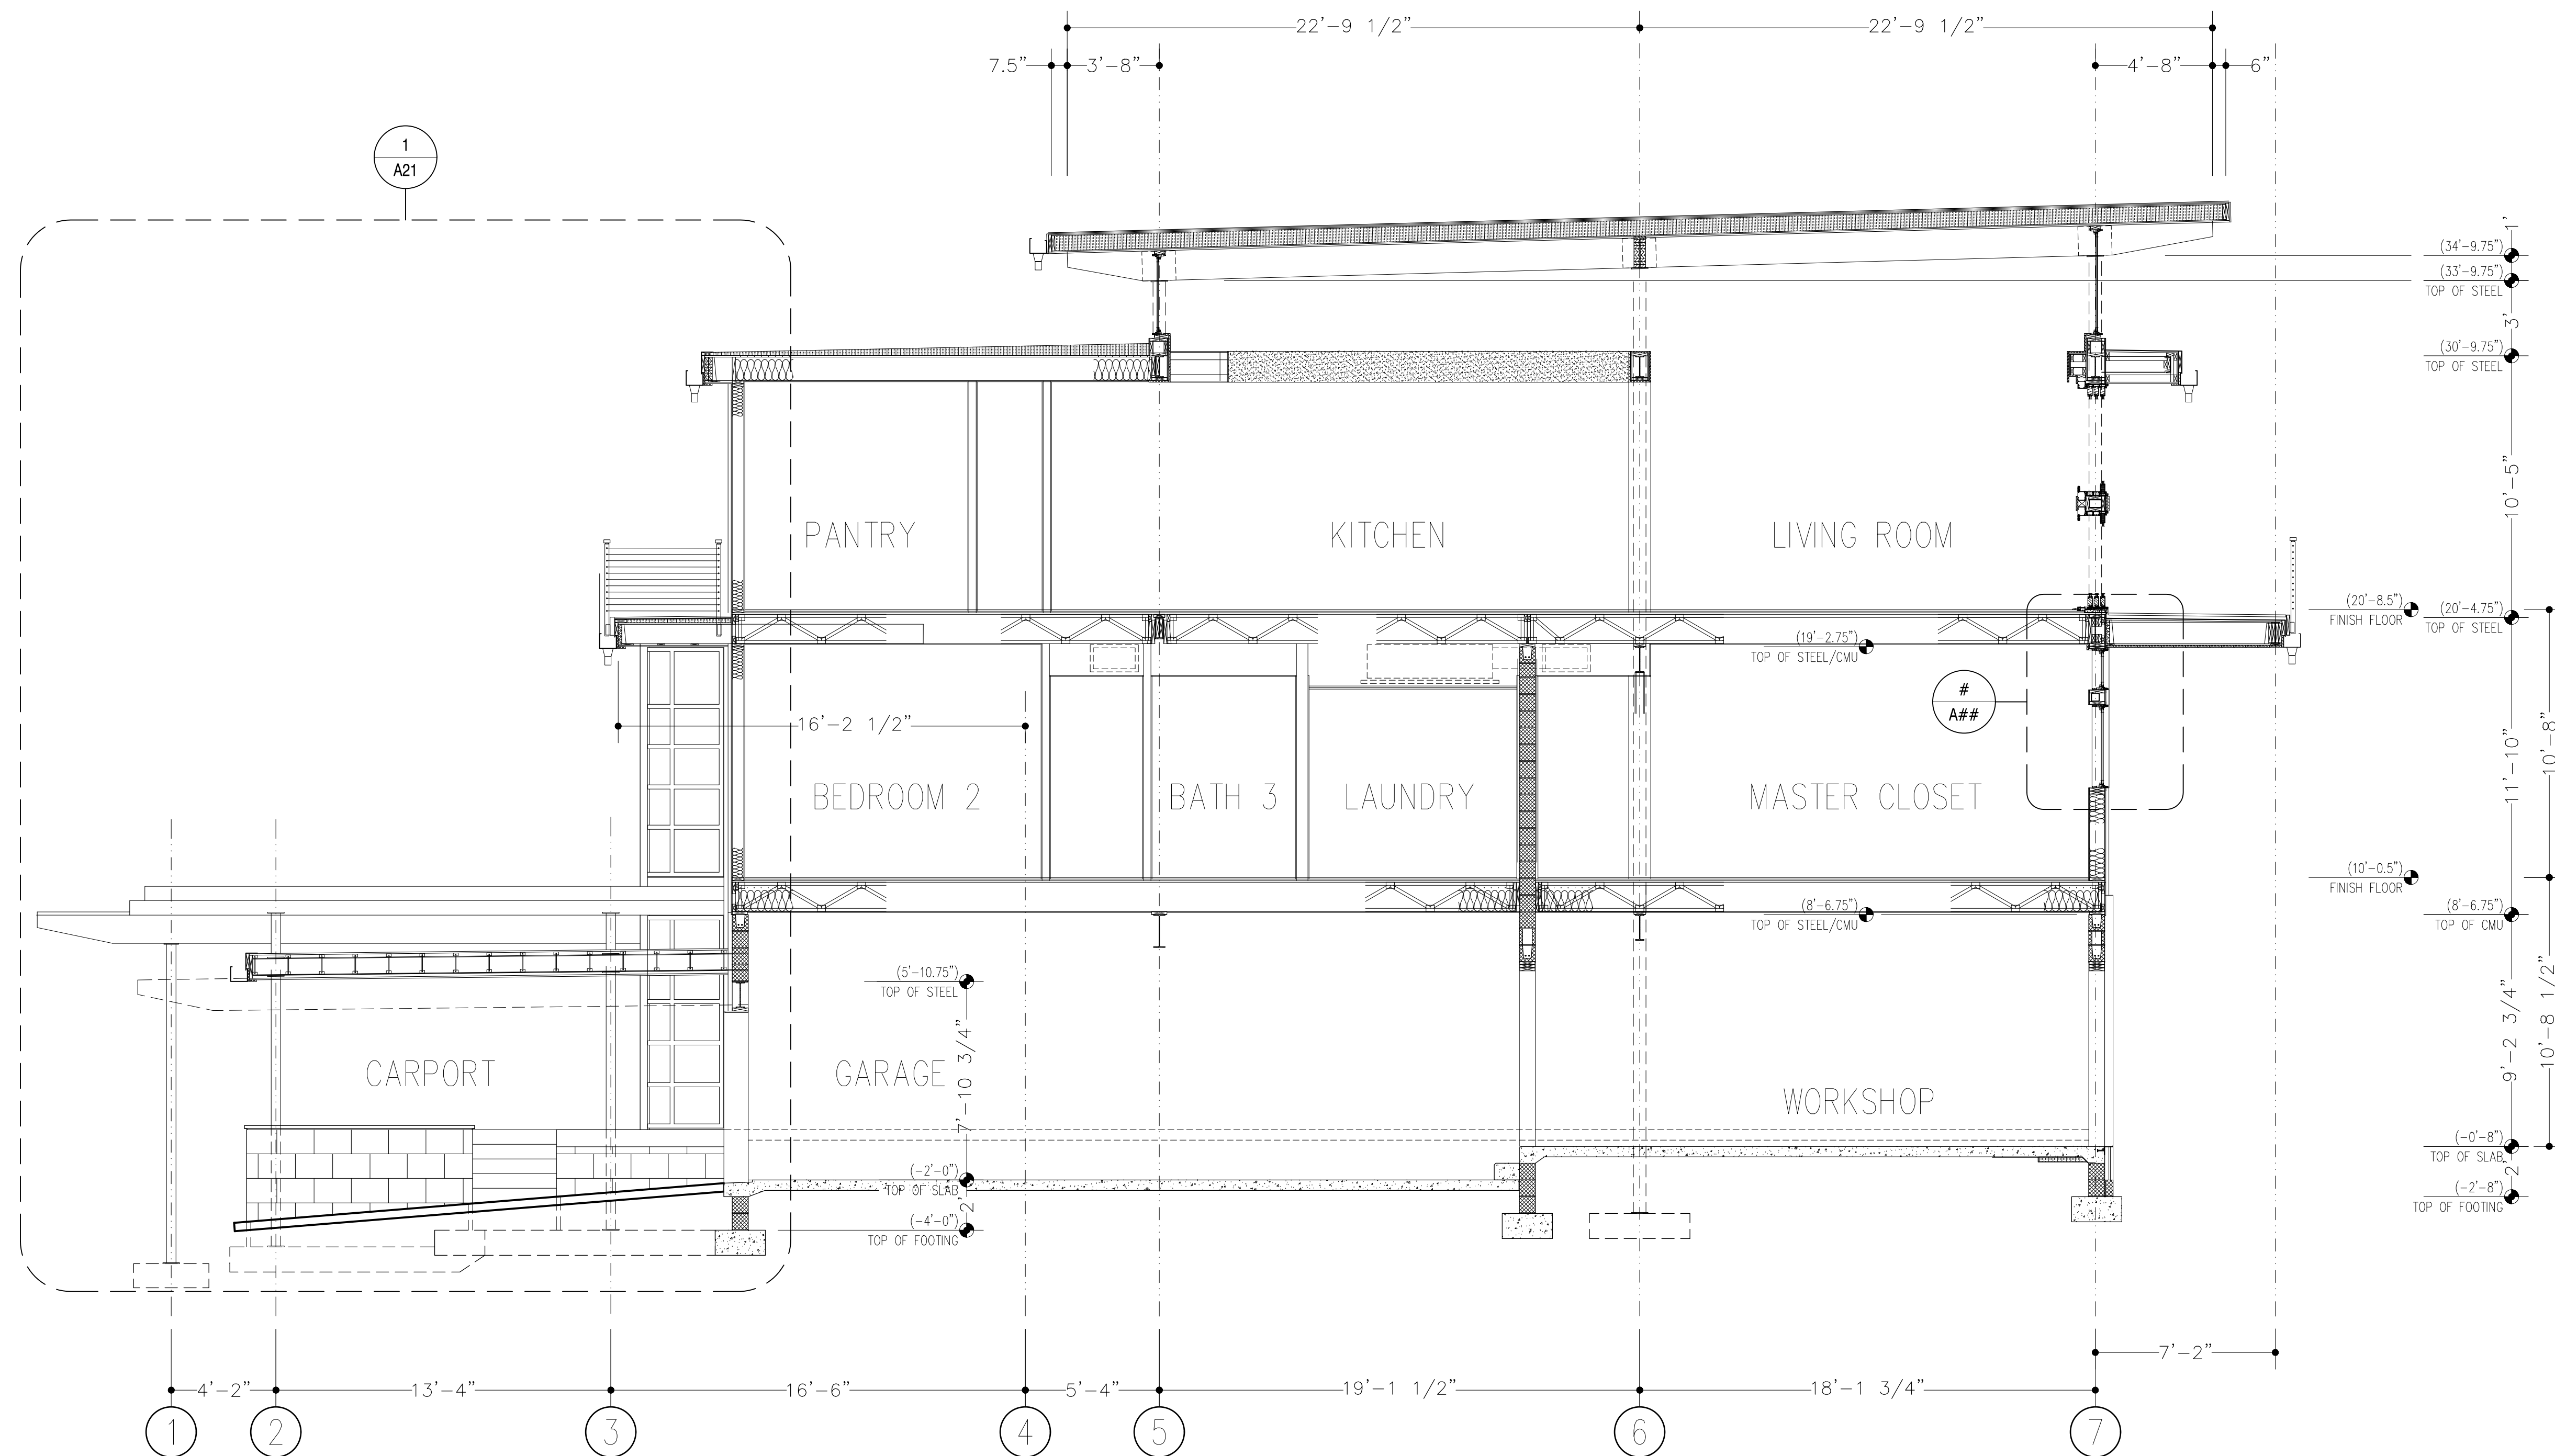

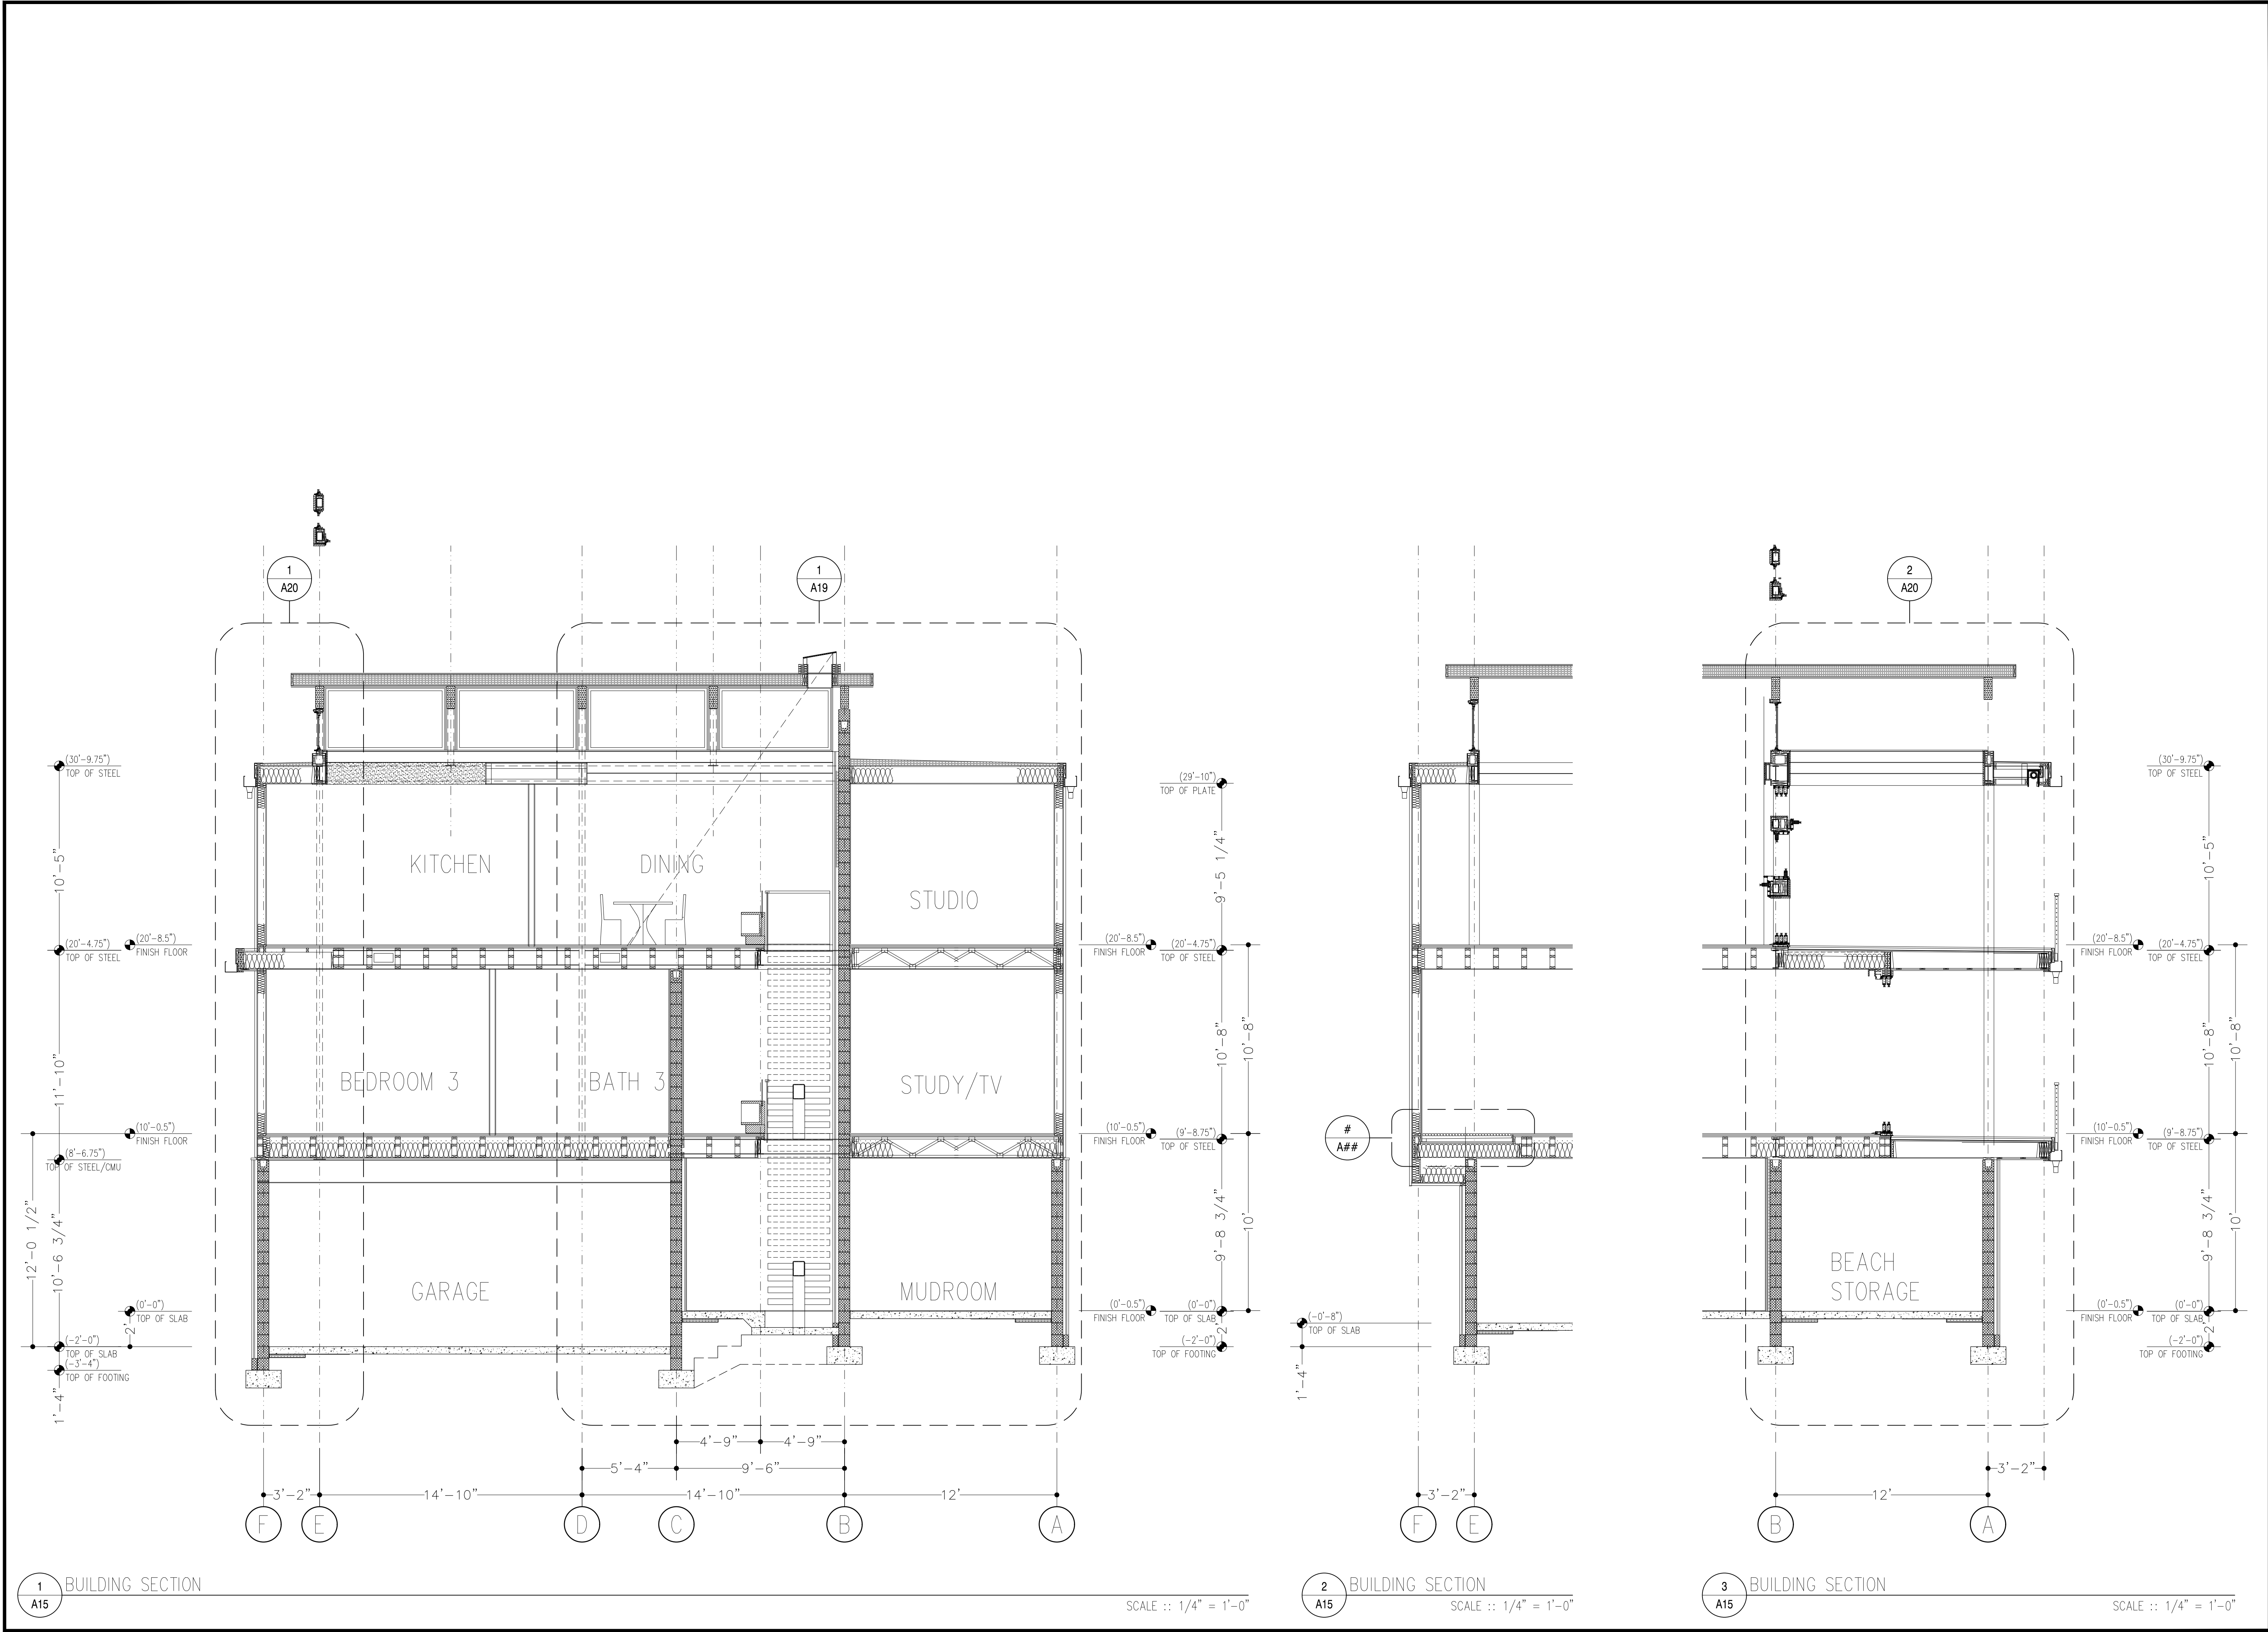

DEBBIE & MICHAEL ROSS RESIDENCE
2726 E OCEAN VIEW AVE

ISSUED FOR:	MARK:	DATE:
75% DESIGN		03-27-22

StudioRoss LLC
223 82nd Street
Virginia Beach, VA 23451
757-323-2209

EAST-WEST
SECTIONS

A15

PLUMBING FIXTURE SCHEDULE <##>

MARK	TYPE	MANUFACTURER	MODEL NO.	FAUCET MANUFACTURER	MODEL NO.	DRAIN MANUFACTURER	MODEL NO.	NOTES
01	37" WIDE FAUX MARBLE TOP w/ INTEGRAL SINK							
02	WATER CLOSET – TANK TYPE							
03	PRE-FAB SHOWER ENCLOSURE							
04	SHOWER HEAD [WALL-MOUNT], FAUCET & DRAIN SET							
05	SHOWER DRAIN							
06	OUTDOOR SHOWER							
07	UTILITY SINK – DROP-IN COUNTERTOP							
08	ICE MACHINE CONNECTION							
09	HOT WATER HEATER – TANKLESS GAS							
10	HOT WATER HEATER							
11	WATER CLOSET – TANK TYPE							
12	PRE-FAB SHOWER ENCLOSURE							
13	SHOWER HEAD [WALL-MOUNT], FAUCET & DRAIN SET							
14	SHOWER DRAIN							
15	VESSEL SINK							
16	BATH TUB – ALCOVE PRE-FAB w/ GLASS SLIDING DOORS							
17	SHOWER HEAD [WALL-MOUNT], FAUCET & DRAIN SET							
18	WATER CLOSET – TANK TYPE							
19	VESSEL SINK							
20	WASHER OUTLET BOX							
21	WATER CLOSET – TANK TYPE							
22	VESSEL SINK							
23	BATH TUB – AIR BUBBLE – FREESTANDING							
24	FAUCET & DRAIN SET							
25	SHOWER HEAD [WALL-MOUNT] & FAUCET SET							
26	LINEAR SHOWER DRAIN							
27	UTILITY SINK – DROP-IN COUNTERTOP							
28	WATER CLOSET – TANK TYPE							
29	VESSEL SINK							
30	KITCHEN SINK – DOUBLE BOWL							
31	DISHWASHER CONNECTION							
32	REFRIGERATOR ICE MACHINE CONNECTION							
33	POT FILLER							
34	ICE MACHINE CONNECTION							

NOTES

- 1 XXXXXXXXXXXXXXXXXXXX
- 2 XXXXXXXXXXXXXXXXXXXX
- 3 XXXXXXXXXXXXXXXXXXXX
- 4 XXXXXXXXXXXXXXXXXXXX
- 5 XXXXXXXXXXXXXXXXXXXX

WINDOW SCHEDULE <A>

MARK	CN	QTY.	RO WIDTH	RO HEIGHT	TYPE	NOTES
A	ELCAP 3719	3	3-1	1-7 5/8	PICTURE	
B	ELAWN 3739	1	3-1	3-3 5/8	AWNING	
B	ELCAP 3739	2	3-1	3-3 5/8	PICTURE	1
C	ELAWN 3735	2	3-1	2-11 5/8	AWNING	1
D	ELCAP 4919	1	4-1	1-7 5/8	PICTURE	
E	ELCAP 4939	1	4-1	3-3 5/8	PICTURE	1
F	ELAWN 4935	1	4-1	2-11 5/8	AWNING	1
G	ELCAP 3319	5	2-9	1-7 5/8	PICTURE	
H	ELCAP 4119	2	3-5	1-7 5/8	PICTURE	
A-H	ELCAP 3719	2	3-1	1-7 5/8	PICTURE	2
	ELCAP 4119	2	3-5	1-7 5/8	PICTURE	2
H-J-H	ELCAP 4119	2	3-5	1-7 5/8	PICTURE	2
	ELCAP 2119	2	1-9	1-7 5/8	PICTURE	2
	ELCAP 4119	2	3-5	1-7 5/8	PICTURE	2
I	ELCAP 3339	2	2-9	3-3 5/8	PICTURE	1
O	ELAWN 3335	2	2-9	2-11 5/8	AWNING	1
K	ELCA 2139-RH	3	1-9	3-3 5/8	CASEMENT	
L	ELCAP ##39	1	2-8*	3-3 5/8	PICTURE	3
M	ELCAP 4139	2	3-5	3-3 5/8	PICTURE	1
N	ELAWN 4135	2	3-5	2-11 5/8	AWNING	1
O-O	ELAWN 3335	1	2-9	2-11 5/8	AWNING	2
	ELAWN 3335	1	2-9	2-11 5/8	AWNING	2
J-P	ELCAP 2119	1	1-9	1-7 5/8	PICTURE	2
	ELCAP 5719	1	4-9	1-7 5/8	PICTURE	2
P-J	ELCAP 5719	1	4-9	1-7 5/8	PICTURE	2
	ELCAP 2119	1	1-9	1-7 5/8	PICTURE	2
Q	ELCA 2139-LH	1	1-9	3-3 5/8	CASEMENT	
R	ELCAP ##19	2	2-8*	1-7 5/8	PICTURE	3
S-1	ELCAP ####	1	6-10*	3-2 3/4*	PICTURE	3,4
S-2	ELCAP ####	1	6-10*	3-2 3/4*	PICTURE	3,4
S-3	ELCAP ####	1	6-10*	3-2 3/4*	PICTURE	3,4
S-4	ELCAP ####	1	6-10*	3-2 3/4*	PICTURE	3,4
N-1	ELCAP ####	1	6-10*	4-2 3/4*	PICTURE	3,4
N-2	ELCAP ####	1	6-10*	4-2 3/4*	PICTURE	3,4
N-3	ELCAP ####	1	6-10*	4-2 3/4*	PICTURE	3,4
N-4	ELCAP ####	1	6-10*	4-2 3/4*	PICTURE	3,4
E-1	ELCAP ####	1	5-8 1/2*	3-7* x 4-2 1/2*	PICTURE-TRAPEZOID	3,4
E-2	ELCAP ####	1	5-8 1/2*	2-11 1/2* x 3-7*	PICTURE-TRAPEZOID	3,4
E-3	ELCAP ####	1	5-8 1/2*	2-4* x 2-11 1/2*	PICTURE-TRAPEZOID	3,4
E-4	ELCAP ####	1	6-0 1/2*	2-2 1/2* x 2-3 1/4*	PICTURE-TRAPEZOID	3,4
E-5	ELCAP ####	1	6-0 1/2*	2-1 3/4* x 2-2 1/2*	PICTURE-TRAPEZOID	3,4
E-6	ELCAP ####	1	6-0 1/2*	2-1* x 2-1 3/4*	PICTURE-TRAPEZOID	3,4
W-1	ELCAP ####	1	5-8 1/2*	4-2 1/2* x 3-7*	PICTURE-TRAPEZOID	3,4
W-1	ELCAP ####	1	5-8 1/2*	3-7* x 2-11 1/2*	PICTURE-TRAPEZOID	3,4
W-1	ELCAP ####	1	5-8 1/2*	2-11 1/2* x 2-4*	PICTURE-TRAPEZOID	3,4

NOTES

- 1 MULL HEADS & SILLS
- 2 MULL JAMBS
- 3 *CUSTOM WIDTH
- 4 *CUSTOM HEIGHT
- 5 BASIS OF DESIGN – MARVIN ELEVATE SERIES

SLIDING GLASS DOOR SCHEDULE <###>

MARK	CN	TYPE	RO WIDTH	RO HEIGHT	NOTES
SL11	8-0 x 8-0	XO	7-8 1/4	8-0 31/32	1,2
SL21	15-0 x 9-0	OXX	14-2 37/64	9-0 31/32	1,3
SL22	8-0 x 9-0	OX	7-8 1/4	9-0 31/32	1,3
SL31	15-0 x 9-0	XXO	14-2 37/64	9-0 31/32	1,3
SL32	15-0 x 9-0	OXX	14-2 37/64	9-0 31/32	1,3
SL33	18-0 x 9-0	OXX	17-2 37/64	9-0 31/32	3
SL34	10-0 x 9-0	XO	9-8 1/4	9-0 31/32	1,3
SL35	8-0 x 9-0	XO	7-8 1/4	9-0 31/32	1,3

NOTES

- 1 PROVIDE RETRACTABLE UNI-DIRECTIONAL SCREEN SE4
- 2 PROVIDE PERFORMANCE SILL
- 3 PROVIDE HIGH PERFORMANCE SILL
- 4 BASIS OF DESIGN – MARVIN ULTIMATE MULTISLIDE GLASS DOOR



DOOR SCHEDULE <###>

MARK	SIZE	TYPE	MATERIAL	HARDWARE	NOTES
101	3-0 x 8-0	A	WOOD ENTRANCE	ENTRY LOCKSET	
102	3-0 x 6-8	J	FIBERGLASS	ENTRY LOCKSET	
103	3-0 x 6-8	B	WOOD PANEL [ELEVATOR]	INTERLOCKING	
104	3-0 x 6-8[PR]	K	FIBERGLASS	ENTRY LOCKSET;T/B RODS	
105	3-0 x 7-10	C	WOOD PANEL	ENTRY LOCKSET	
106	3-0 x 6-8[PR]	K	FIBERGLASS	ENTRY LOCKSET;T/B RODS	
107	3-0 x 6-8	J	FIBERGLASS	ENTRY LOCKSET	
108	3-0 x 7-10	C	WOOD PANEL	PASSAGE	
109	2-0 x 6-8	J	WOOD	PRIVACY	
110	2-6 x 6-8	J	WOOD	ENTRY LOCKSET	
111	3-0 x 6-8[PR]	K	FIBERGLASS	ENTRY LOCKSET;T/B RODS	
112	3-0 x 6-8[PR]	K	FIBERGLASS	ENTRY LOCKSET;T/B RODS	
201	2-0 x 6-8	J	WOOD PANEL	PASSAGE	
202	2-8 x 6-8	J	WOOD PANEL	PRIVACY	
203	3-0 x 6-8	B	WOOD PANEL [ELEVATOR]	INTERLOCKING	
204	2-0 x 6-8	J	WOOD PANEL	PRIVACY	
205	2-8 x 6-8	J	WOOD PANEL	PRIVACY	
206	2-0 x 6-8	J	WOOD PANEL	SLIDING POCKET	
207	2-0 x 6-8	J	WOOD PANEL	PRIVACY	
208	2-6 x 6-8[PR]	L	MIRROR PANEL	SLIDING TRACK	
209	2-8 x 6-8	C	WOOD PANEL	PASSAGE	
210	2-8 x 6-8	C	WOOD PANEL	PRIVACY	
211	3-6 x 8-0	G	WOOD PANEL	SLIDING BARN TRACK	
212	2-6 x 6-8[PR]	F	WOOD PANEL	SLIDING POCKET	
213	2-0 x 6-8	D	WOOD PANEL	PASSAGE	
214	2-8 x 6-8	E	WOOD PANEL	SLIDING POCKET	
215	2-0 x 6-8[PR]	L	MIRROR PANEL	SLIDING TRACK	
216	3-0 x 6-8	?	GLASS	GLASS SLIDING TRACK	
217	3-0 x 6-8	C	WOOD PANEL	PRIVACY	
218	4-0 x 8-0	G	WOOD PANEL	SLIDING BARN TRACK	
219	2-6 x 8-0[PR]	M	WOOD PANEL	SLIDING TRACK	
220	3-0 x 8-0	H	GLASS EXTERIOR	ENTRANCE	
301	3-0 x 6-8	C	WOOD PANEL	PASSAGE	
302	3-0 x 6-8	C	WOOD PANEL	PRIVACY	
303	3-0 x 6-8	B	WOOD PANEL [ELEVATOR]	INTERLOCKING	
304	3-0 x 6-8	C	WOOD PANEL	SLIDING POCKET	
305	2-0 x 6-8	C	WOOD PANEL	PASSAGE	
306	3-6 x 8-0	G	WOOD PANEL	SLIDING BARN TRACK	

NOTES

- 1 XXX

DOOR TYPES

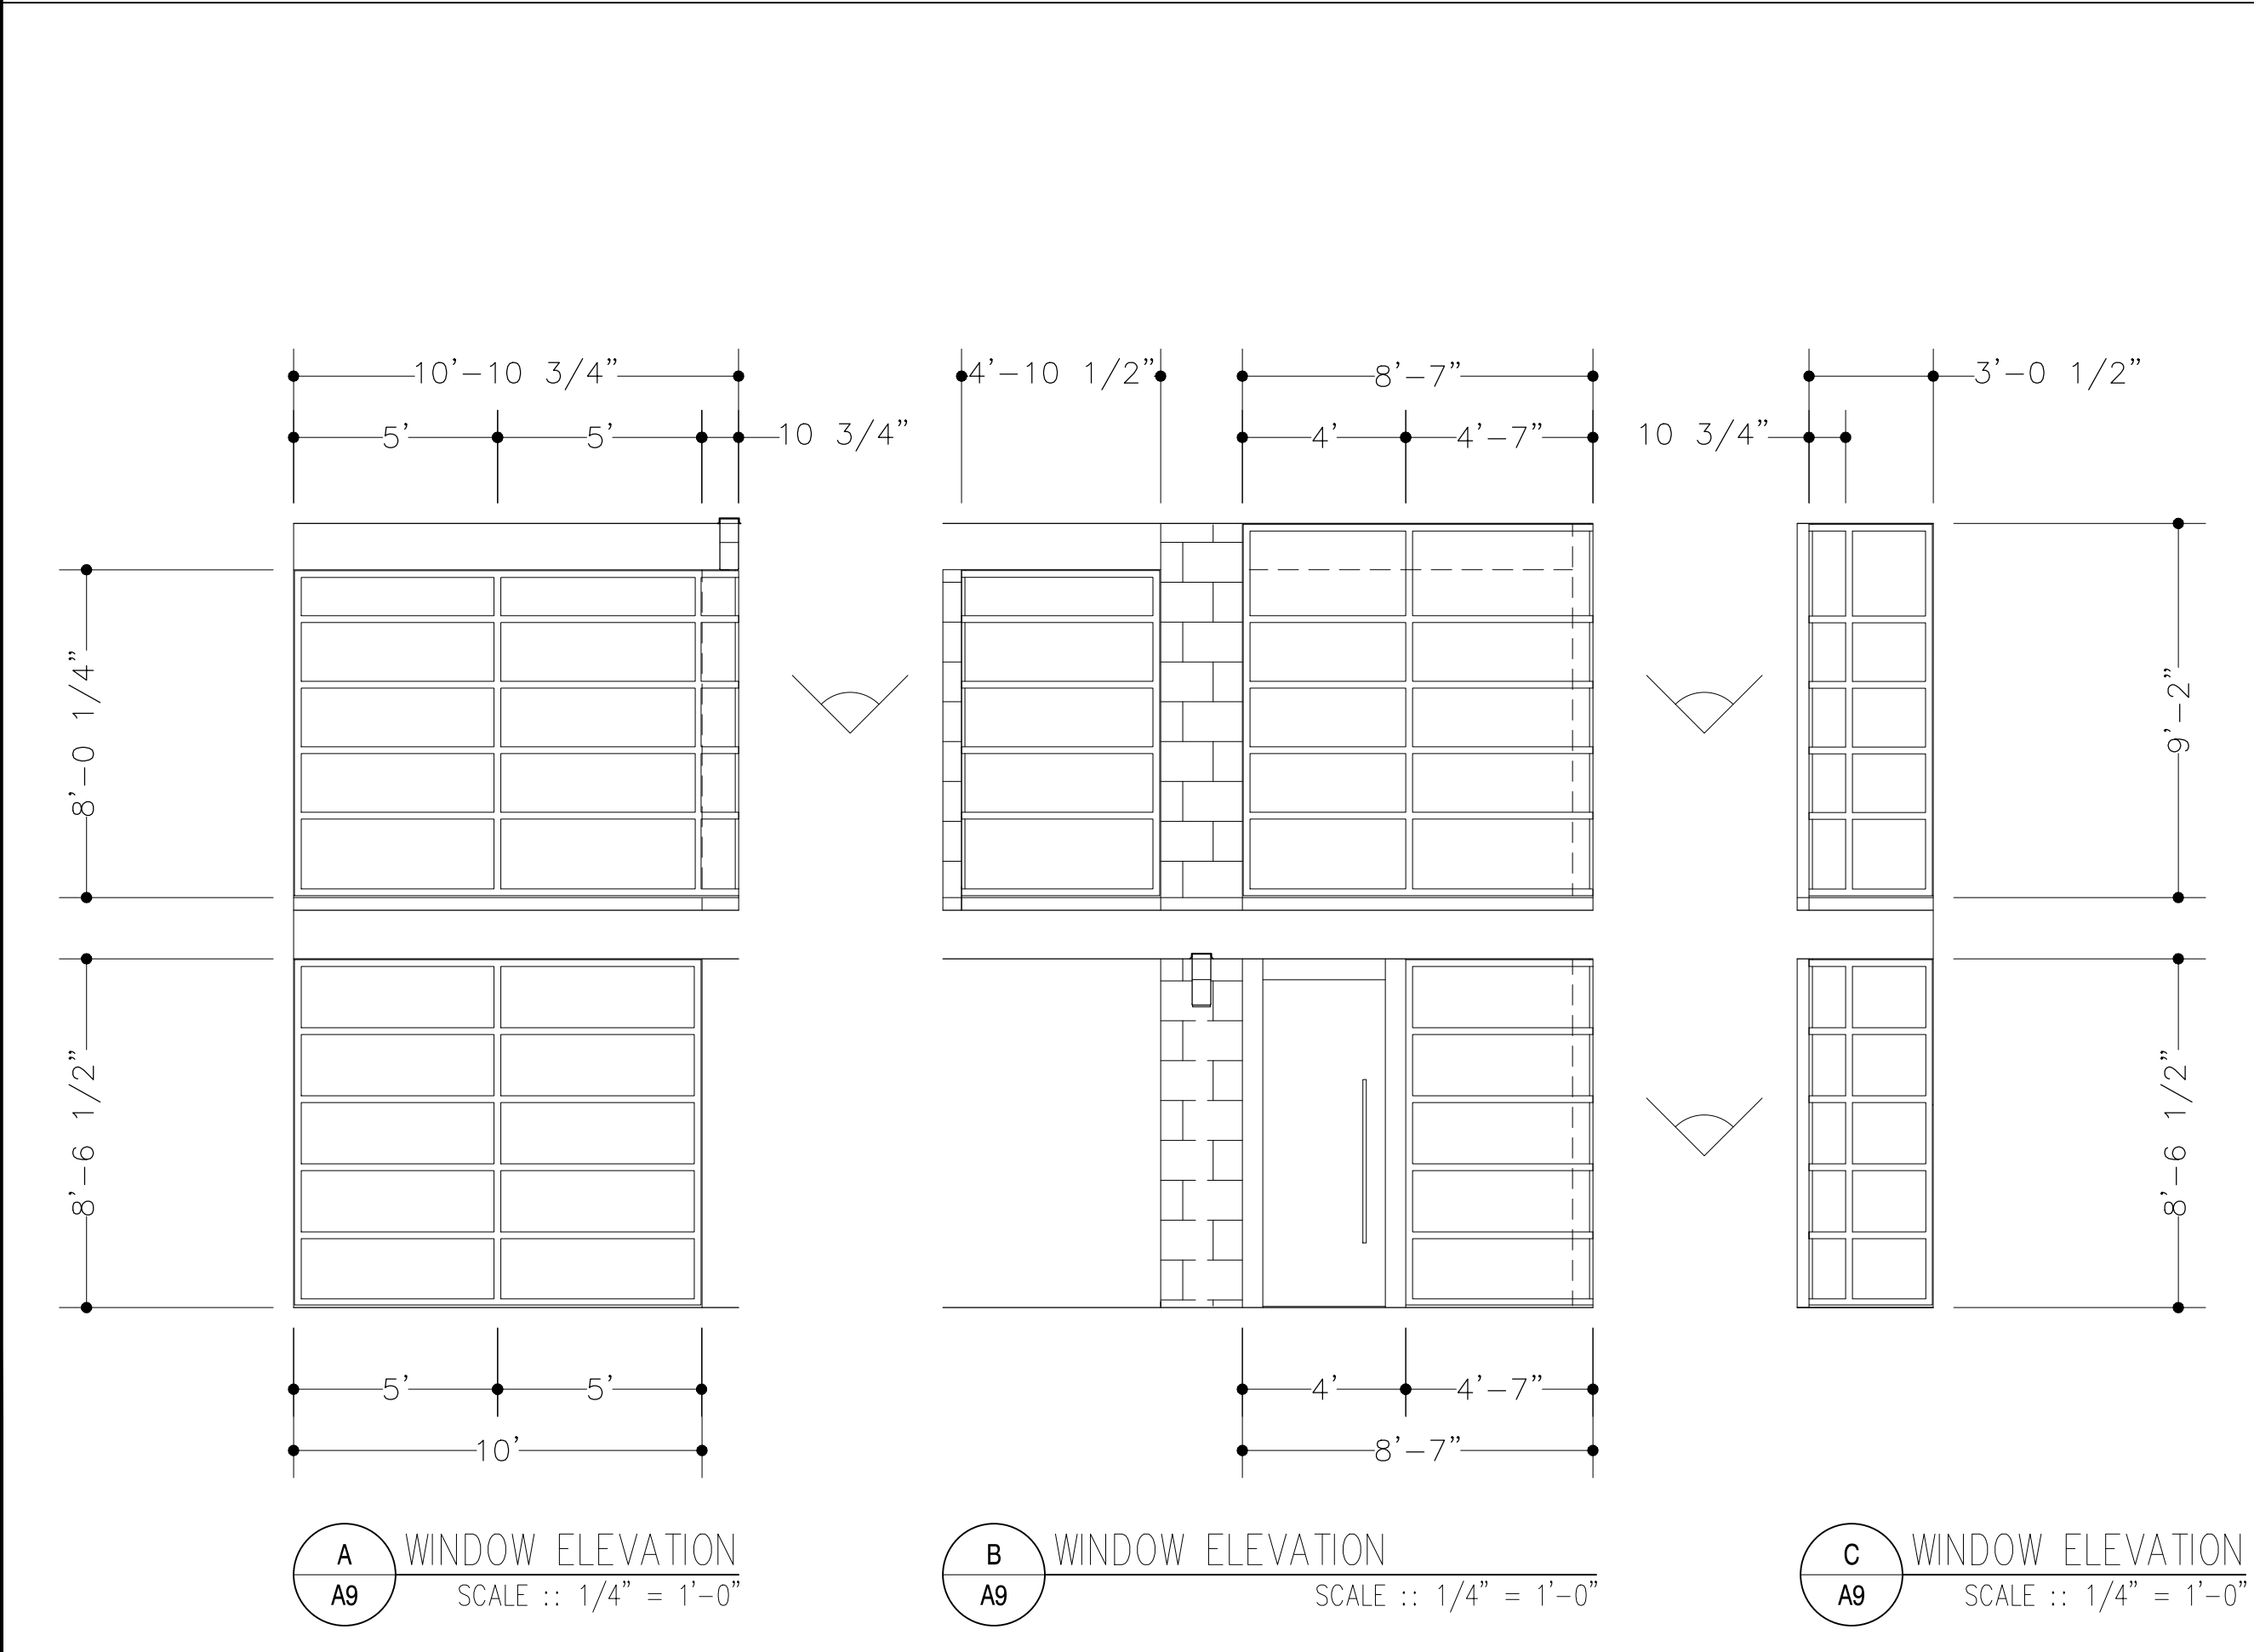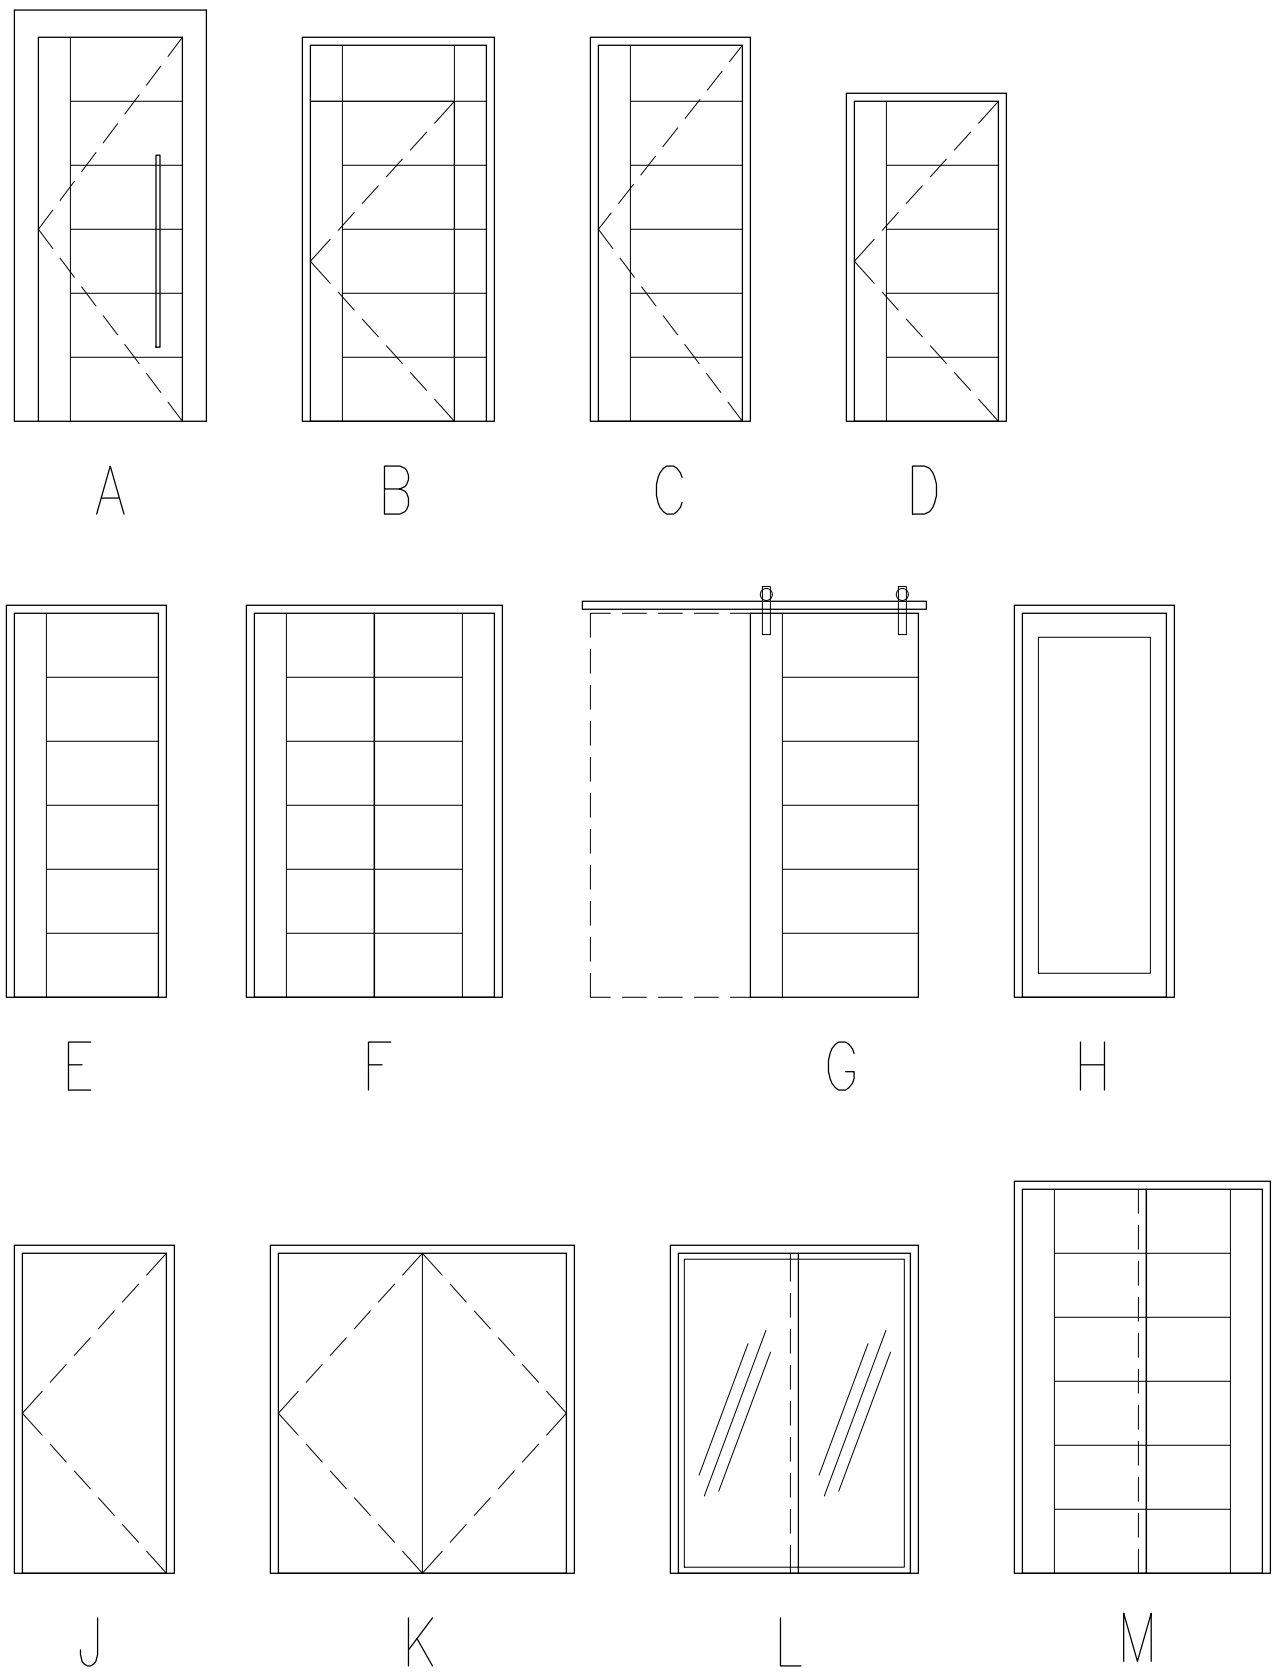

DEBBIE & MICHAEL ROSS RESIDENCE
2726 E OCEAN VIEW AVE

ISSUED FOR: MARK: DATE: 03-27-22
75% DESIGN

StudioRoss LLC
223 82nd Street
Virginia Beach, VA 23451
757-323-2209

DOORS AND
WINDOWS

A23